




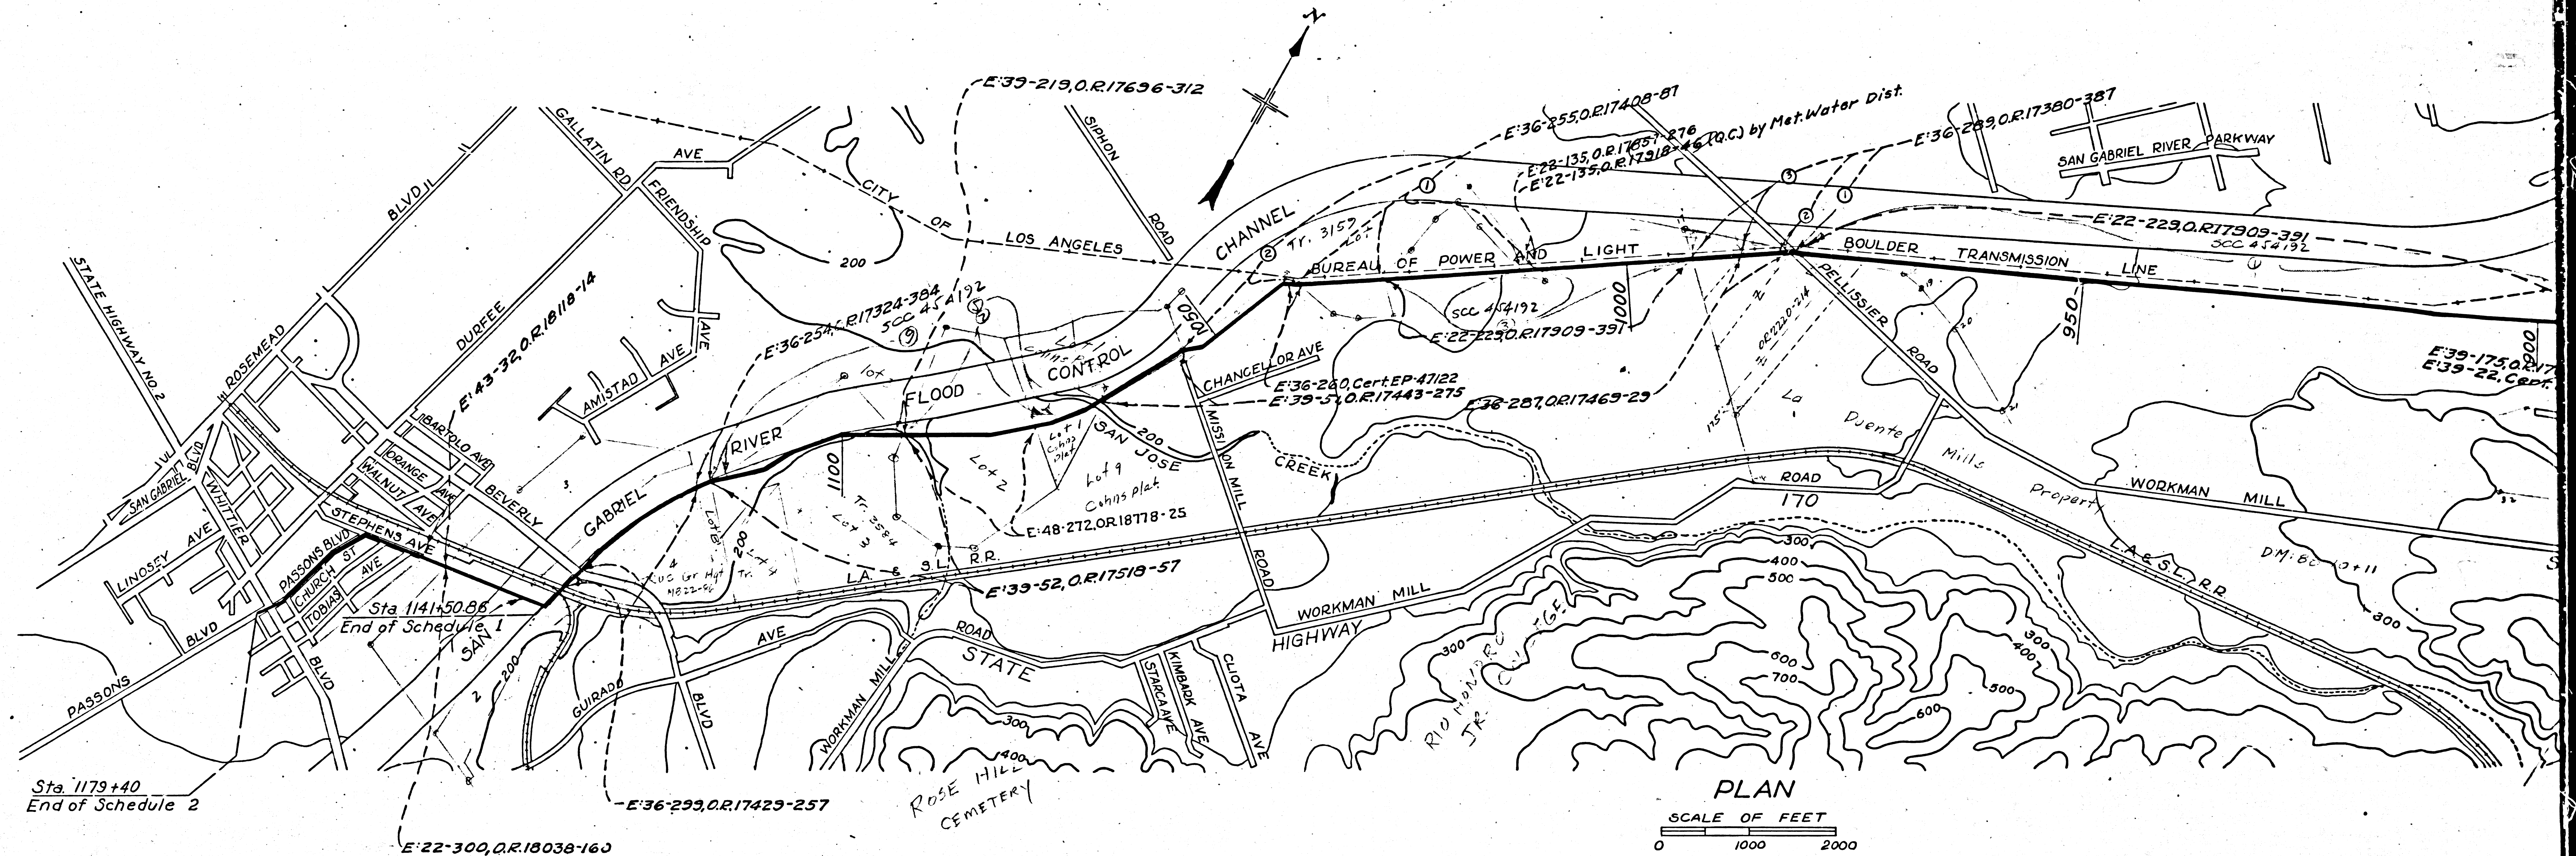


PLAN
SCALE OF FEET
0 1000 2000

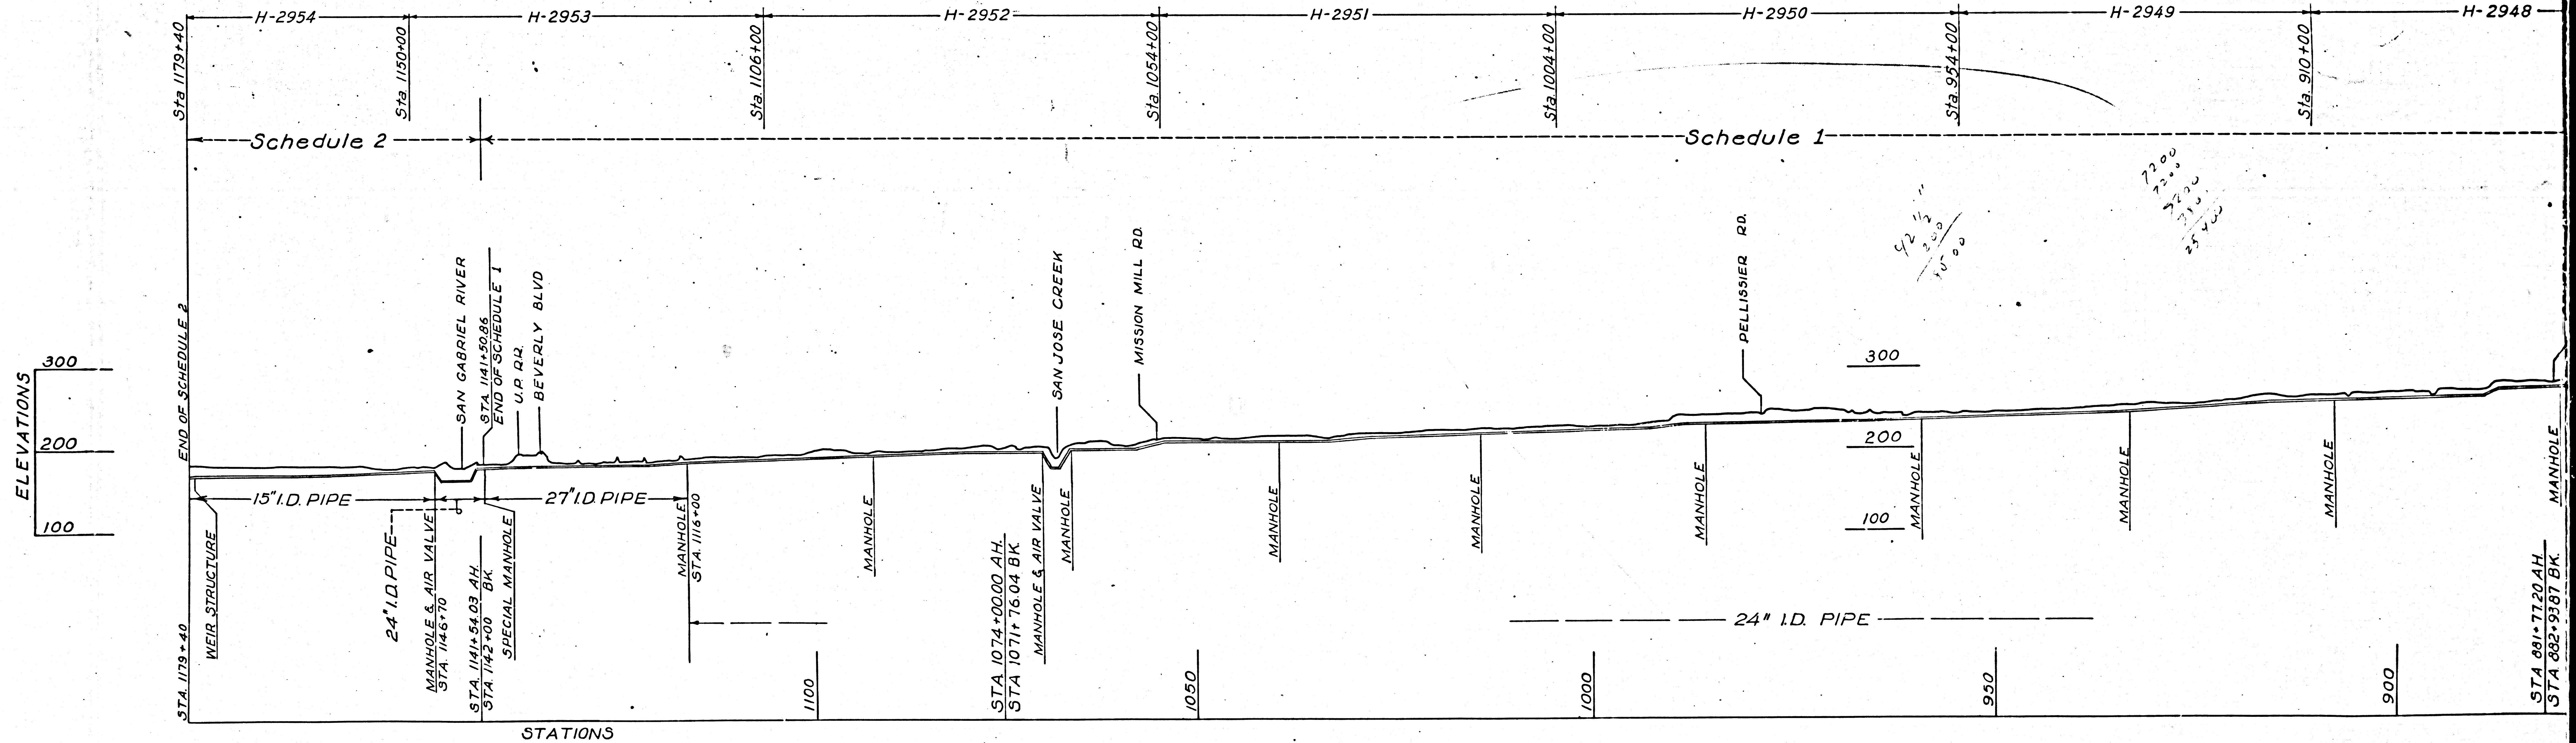

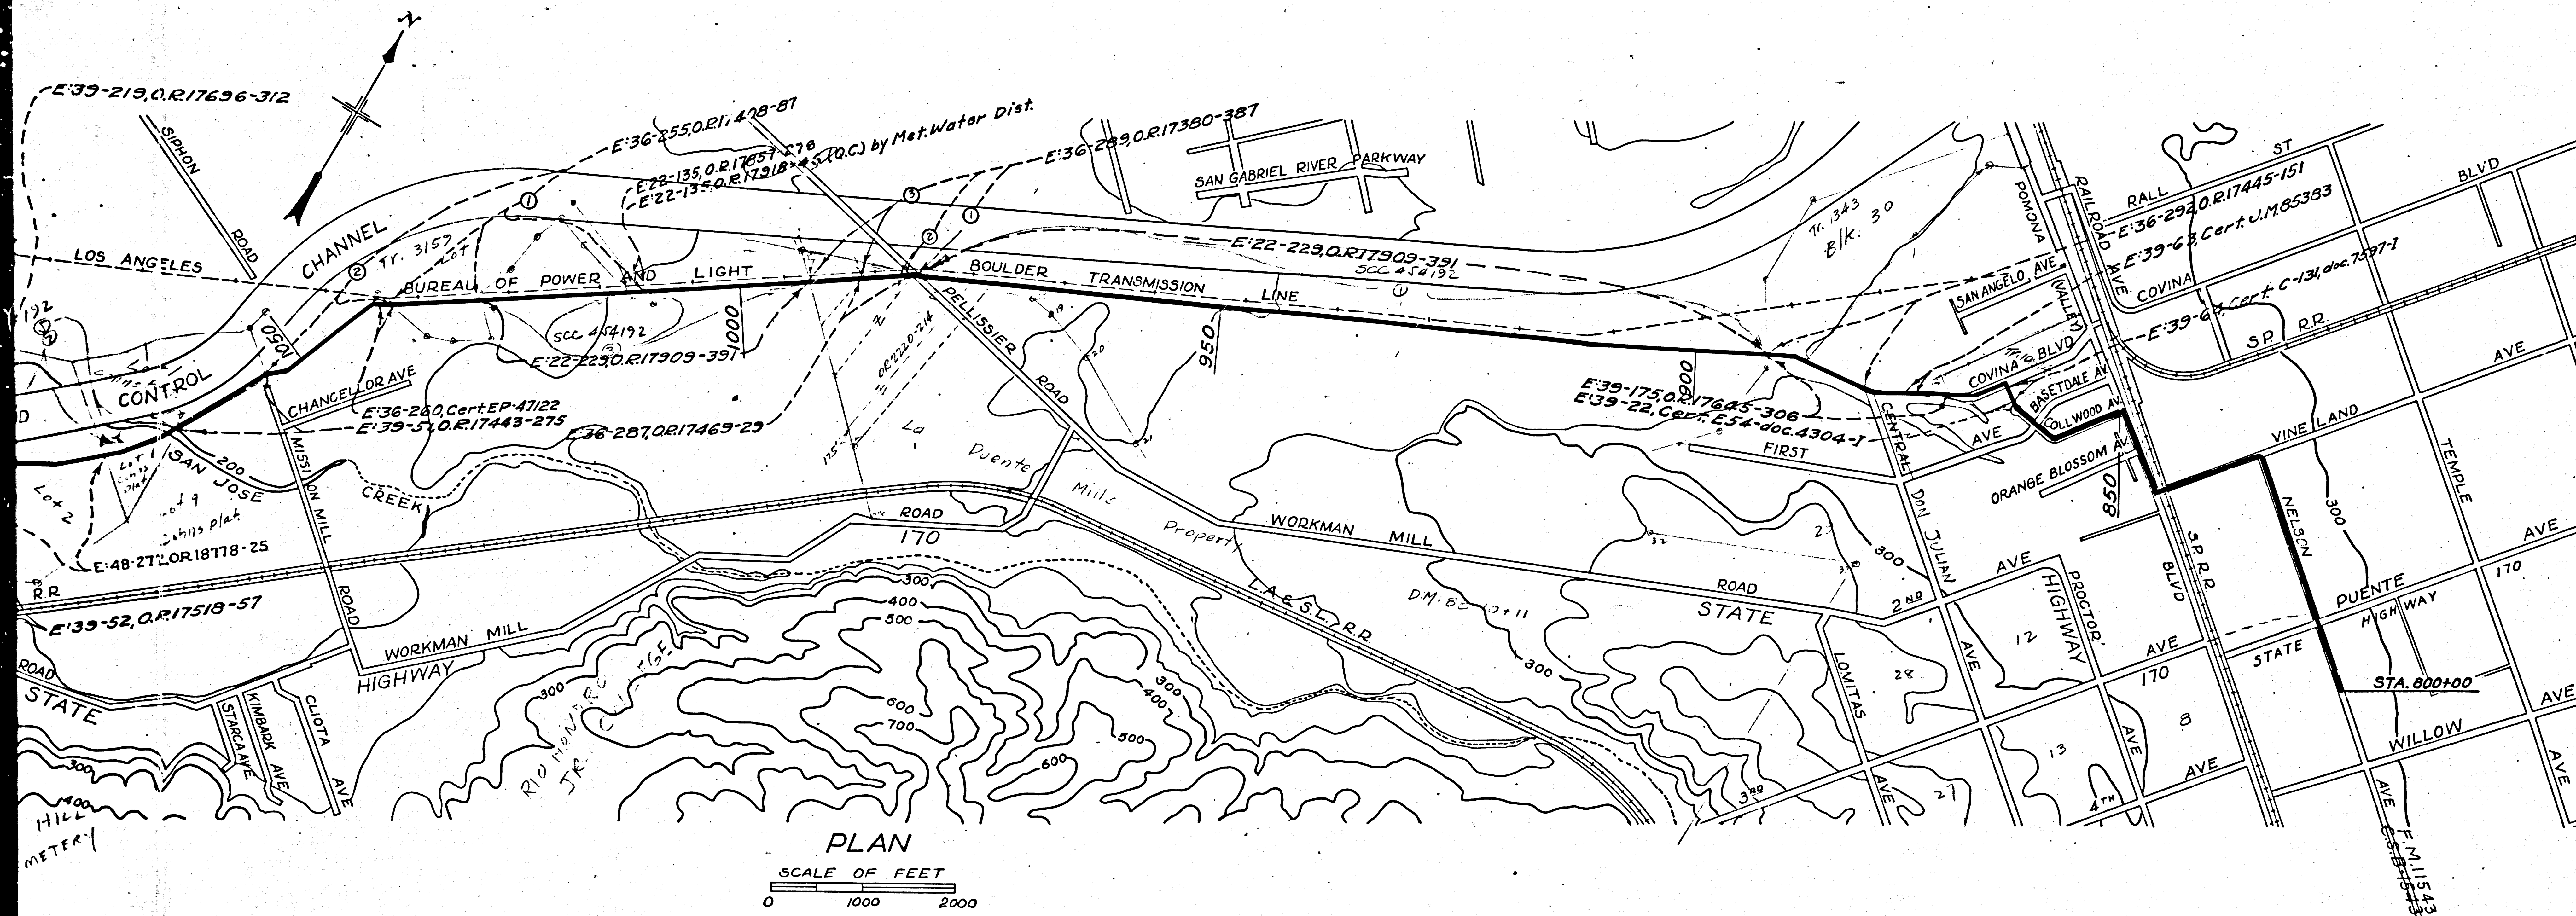

PLAN
SCALE OF FEET
0 1000 2000

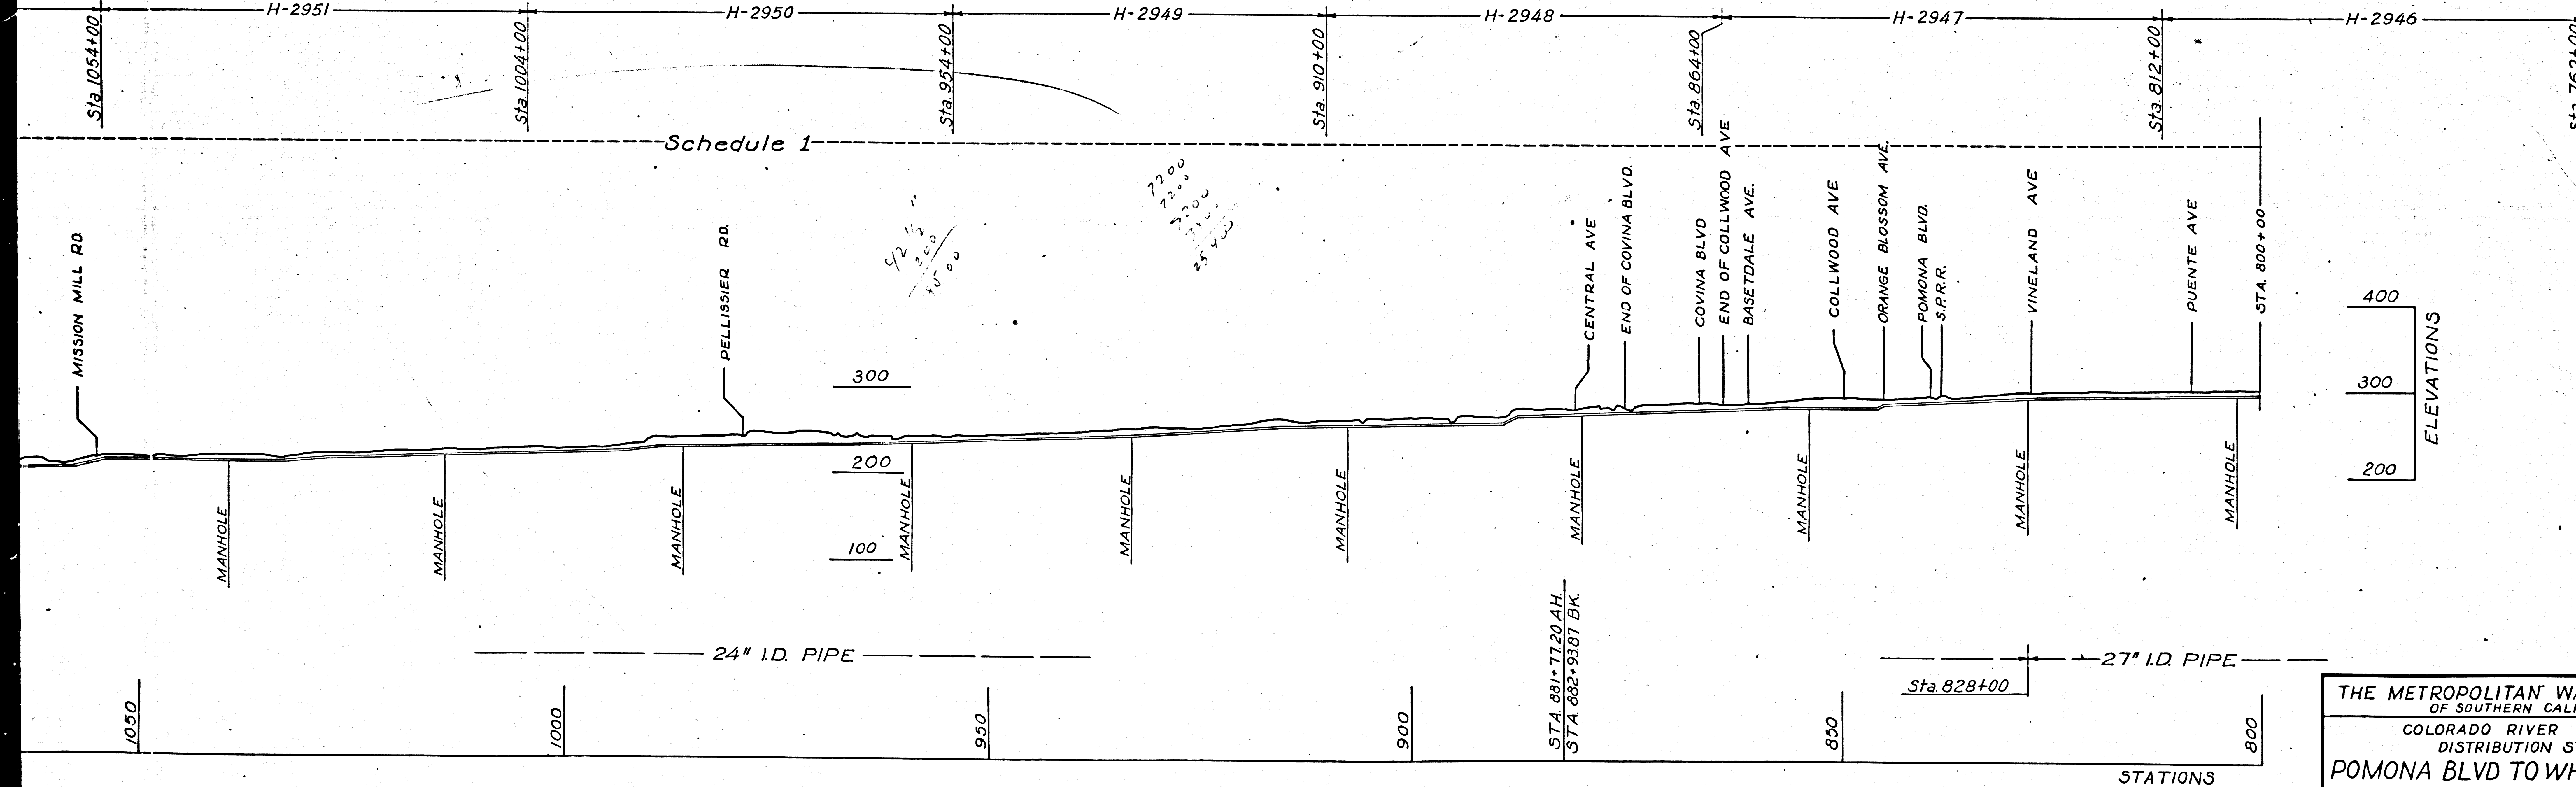

ELEVATIONS
400
300
200

STATIONS

F.M.	11	5	4	3	-	3
A	2	OF	A	2		

THE METROPOLITAN WATER DISTRICT
OF SOUTHERN CALIFORNIA
COLORADO RIVER AQUEDUCT
DISTRIBUTION SYSTEM
POMONA BLVD TO WHITTIER BLVD
WASTE WATER LINE
GENERAL PLAN AND PROFILE

DRAWN... R.R.L.S. RECOMMENDED... R.R.L.S.
TRACED... R.R.L.S. APPROVED... R.R.L.S.
CHECKED... R.R.L.S.
LOS ANGELES FEB. 1940 H-2927
NEG. 463 Sht. 3