

CHALMERS & BARNETT
 CIVIL ENGINEERS
 35 SOUTH RAYMOND AVE.
 PASADENA - CALIFORNIA

KATHERINE BASHFORD
FRED BARLOW, JR.
 LANDSCAPE ARCHITECTS
 816 WEST FIFTH STREET
 LOS ANGELES - CALIFORNIA

ELLIOTT LEE ELLINGWOOD
 MECHANICAL & ELECTRICAL
 ENGINEER
 124 WEST FOURTH STREET
 LOS ANGELES - CALIFORNIA

HOWARD G. SMITS
 STRUCTURAL ENGINEER
 300 WIGMORE DRIVE
 PASADENA - CALIFORNIA

HARBOR HILLS HOUSING PROJECT
 THE HOUSING AUTHORITY OF THE COUNTY OF LOS ANGELES, CALIFORNIA
 COMMISSIONERS: ISIDORE B. DOCKWEILER, CHAIRMAN; W. A. SIMPSON, VICE-CHAIRMAN; ROBERT WAYNE BURNS, MRS. MARGARETE L. CLARK, JOSEPH E. SCHUMACHER
 EXECUTIVE DIRECTOR: MELVILLE DOZIER, JR.

ASSOCIATED ARCHITECTS
 816 WEST FIFTH STREET - LOS ANGELES, CALIFORNIA
 REGINALD D. JOHNSON, F.A.I.A., DONALD B. PARKINSON, A.I.A., EUGENE WESTON, A.I.A., LEWIS EUGENE WILSON, A.I.A., CLARENCE S. STEIN, F.A.I.A., A. C. ZIMMERMAN, A.I.A.
 CONSULTING ARCHITECT

SEWER SYSTEM PLANS AND PROFILES

U.S.R.A. CAL 2-2
 SHEET NO. 1102A

COUNTY OF LOS ANGELES
CALIFORNIA
OFFICE OF COUNTY SURVEYOR


LIST OF PARTS AND ACCESSORIES TO BE FURNISHED WITH FLAP VALVE FOR INSTALLATION IN STANDARD FLUSHING MANHOLE 3'-0" DIA. AND STANDARD DOUBLE FLUSHING MANHOLE 5'-0" DIA.

ITEM NO.	QUANTITY	DESCRIPTION
1	1	8 DIA. CAST IRON FLAP VALVE BODY (BRONZE GASKET)
2	1	BRONZE CAST IRON FLAP VALVE COVER
3	1	1/2" DIA. X 8" BRASS ROD CALLED FOR LETTER PHS AS PER PLAN
4	2	24 IN. LBS. WASHERS
5	2	1/2" X 8" BRASS WASHERS
6	1	1/2" X 8" BRASS WASHERS
7	1	1/2" X 8" BRASS WASHERS
8	1	1/2" X 8" BRASS WASHERS
100	1	1/2" X 8" BRASS WASHERS

WHEN FURNISHING PARTS FOR STANDARD DOUBLE FLUSHING MANHOLE 5'-0" DIA. THE QUANTITY IN ITEM NOS. 1 THROUGH 100 SHOULD BE DOUBLED.

DATE: 1/15/33
DRAWN BY: J. H. BARNETT
CHECKED BY: J. H. BARNETT

No. S-8-59

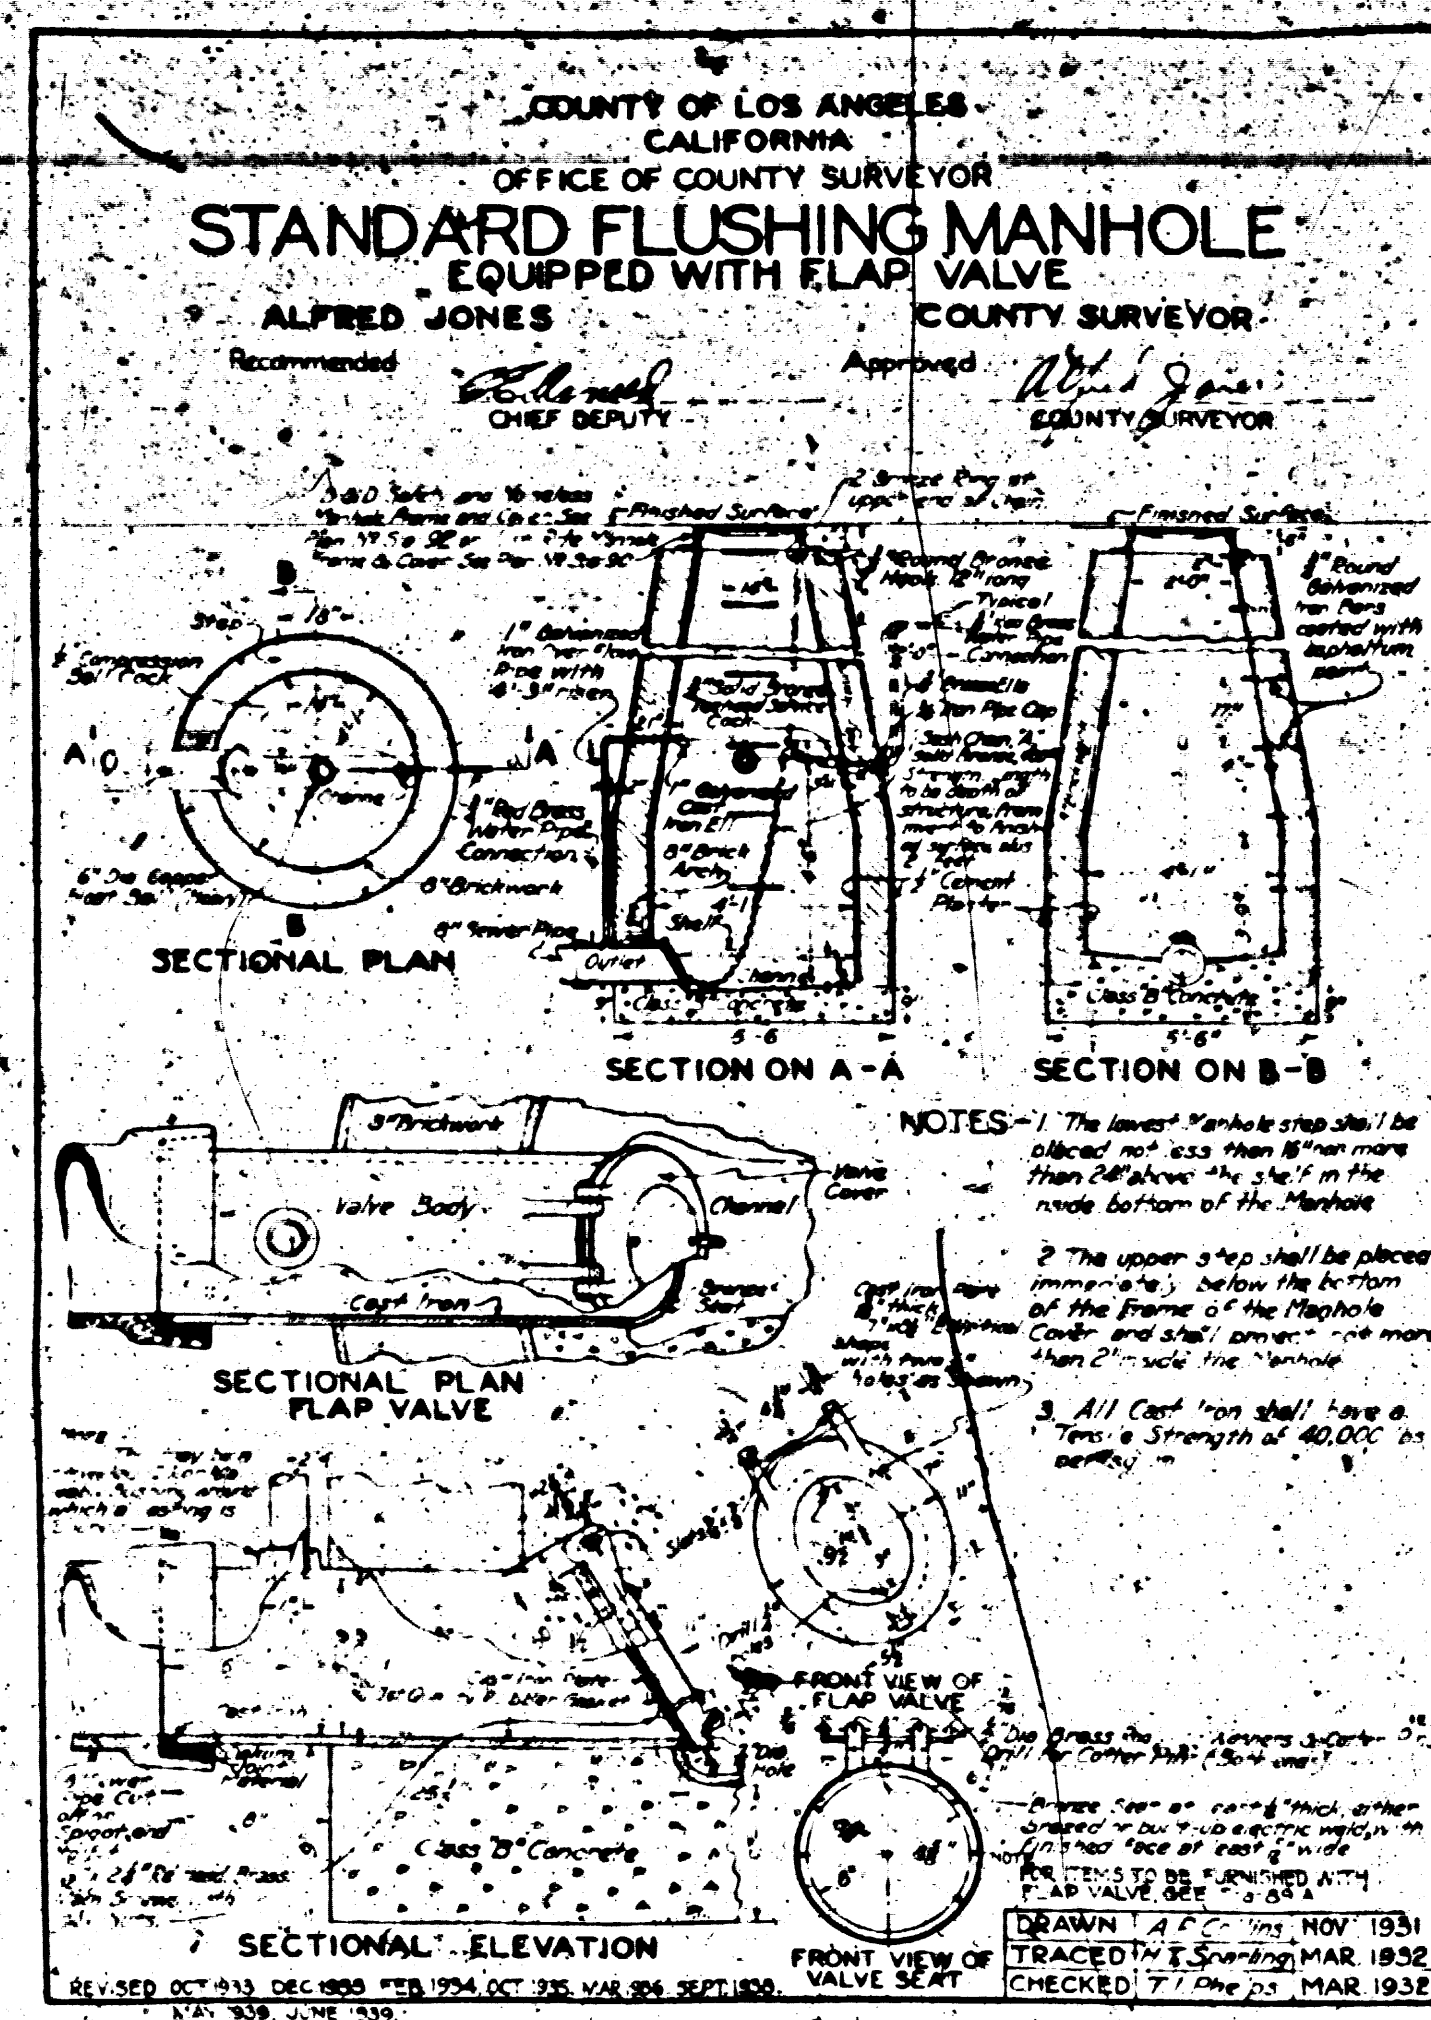



NOTES:
STANDARD MANHOLE TO BE SAME AS SHOWN PRESENT FOR FLUSHING MANHOLE EXCEPT WITH FLUSHING VALVE & ACCESSORIES CHANGED. MANHOLE SHALL NOT BE LARGER THAN THAT OF MANHOLE. ELEVATIONS OF TOPS OF MANHOLES ARE APPROXIMATE. NO FLUSHING MANHOLES REQUIRED.

ALL MAIN LINE CONNECTIONS TO BE 12" DIA. TRUNK OF HOUSE CONNECTIONS IS AS FOLLOWS: APPROXIMATELY 4" OUTSIDE OF FOUNDATION LINE ON ALL BUILDINGS AND 4 1/2" FROM CORNER OF BUILDINGS 17, 20, 26, 27, 30, 31 & 42. 6" FROM CORNER OF ALL OTHERS EXCEPT 24. CONTRACTOR SHALL CONSULT PLUMBING PLANS FOR ELEVATIONS OF PIPE LINES FROM BUILDINGS.

VOID

VOID

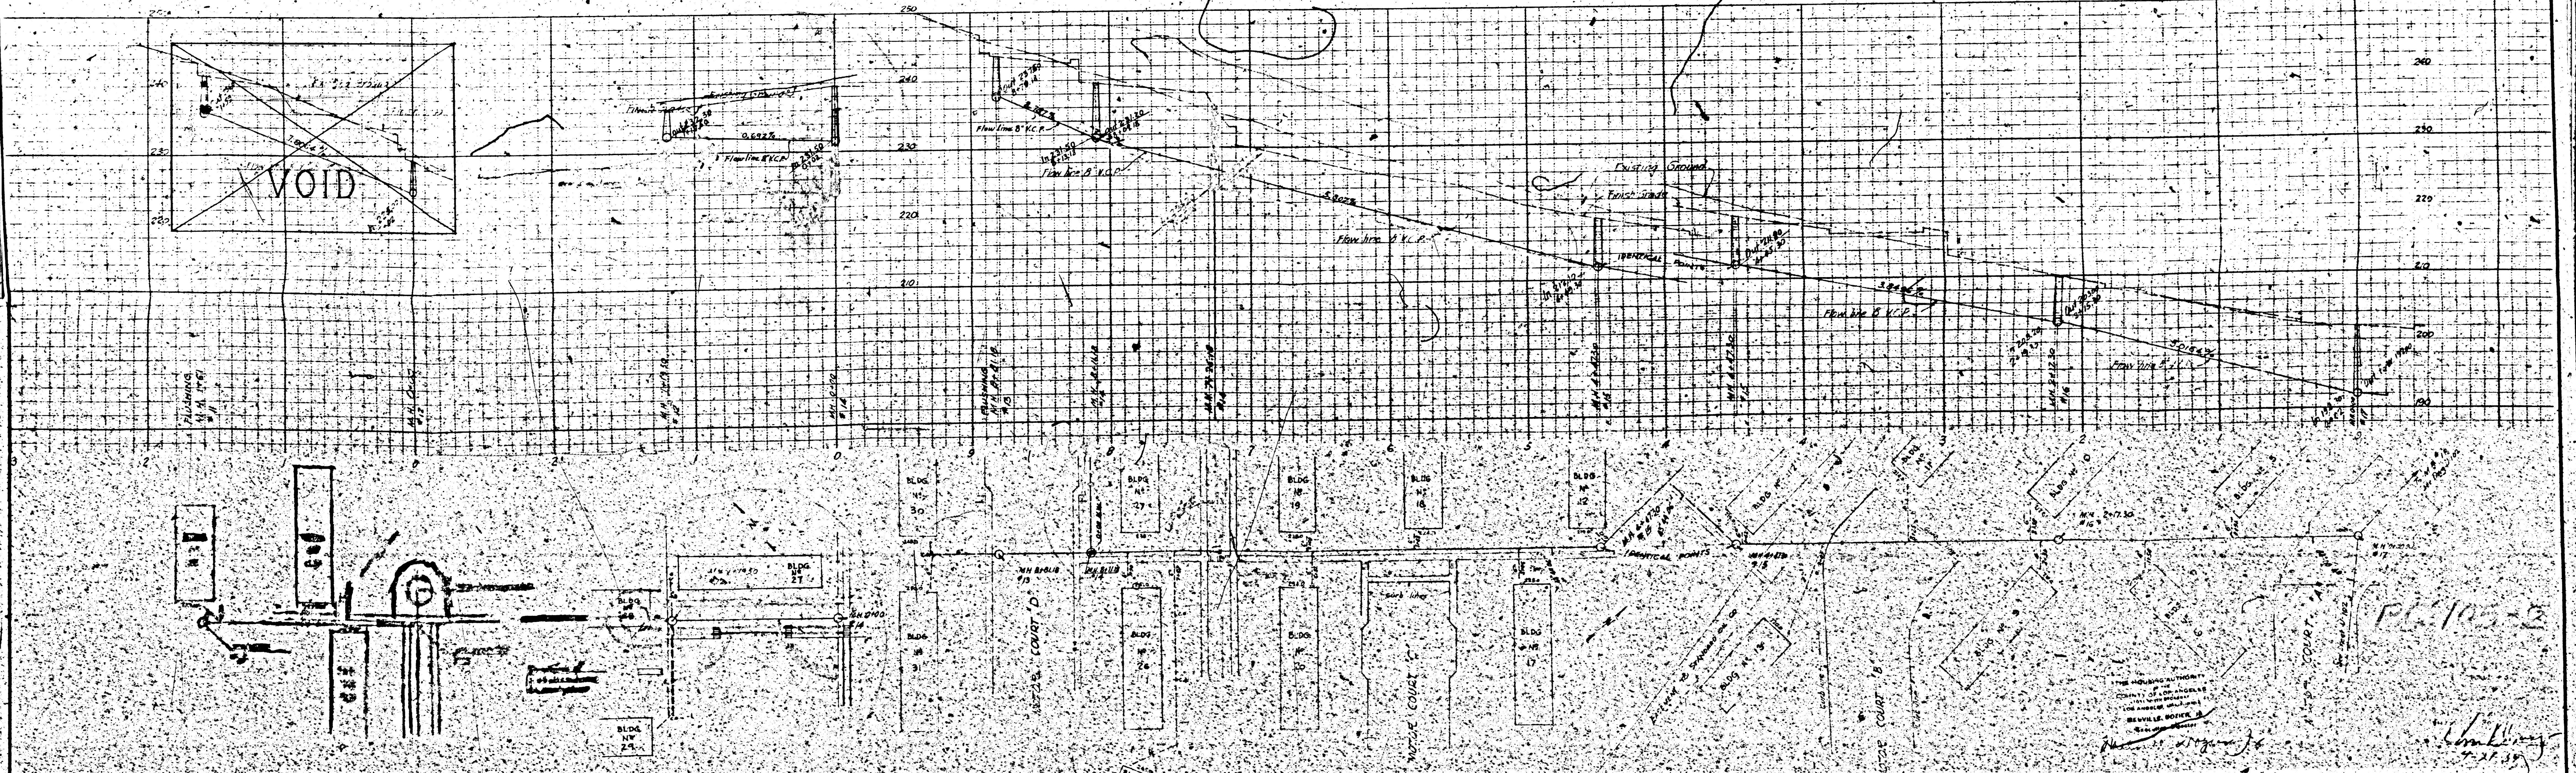

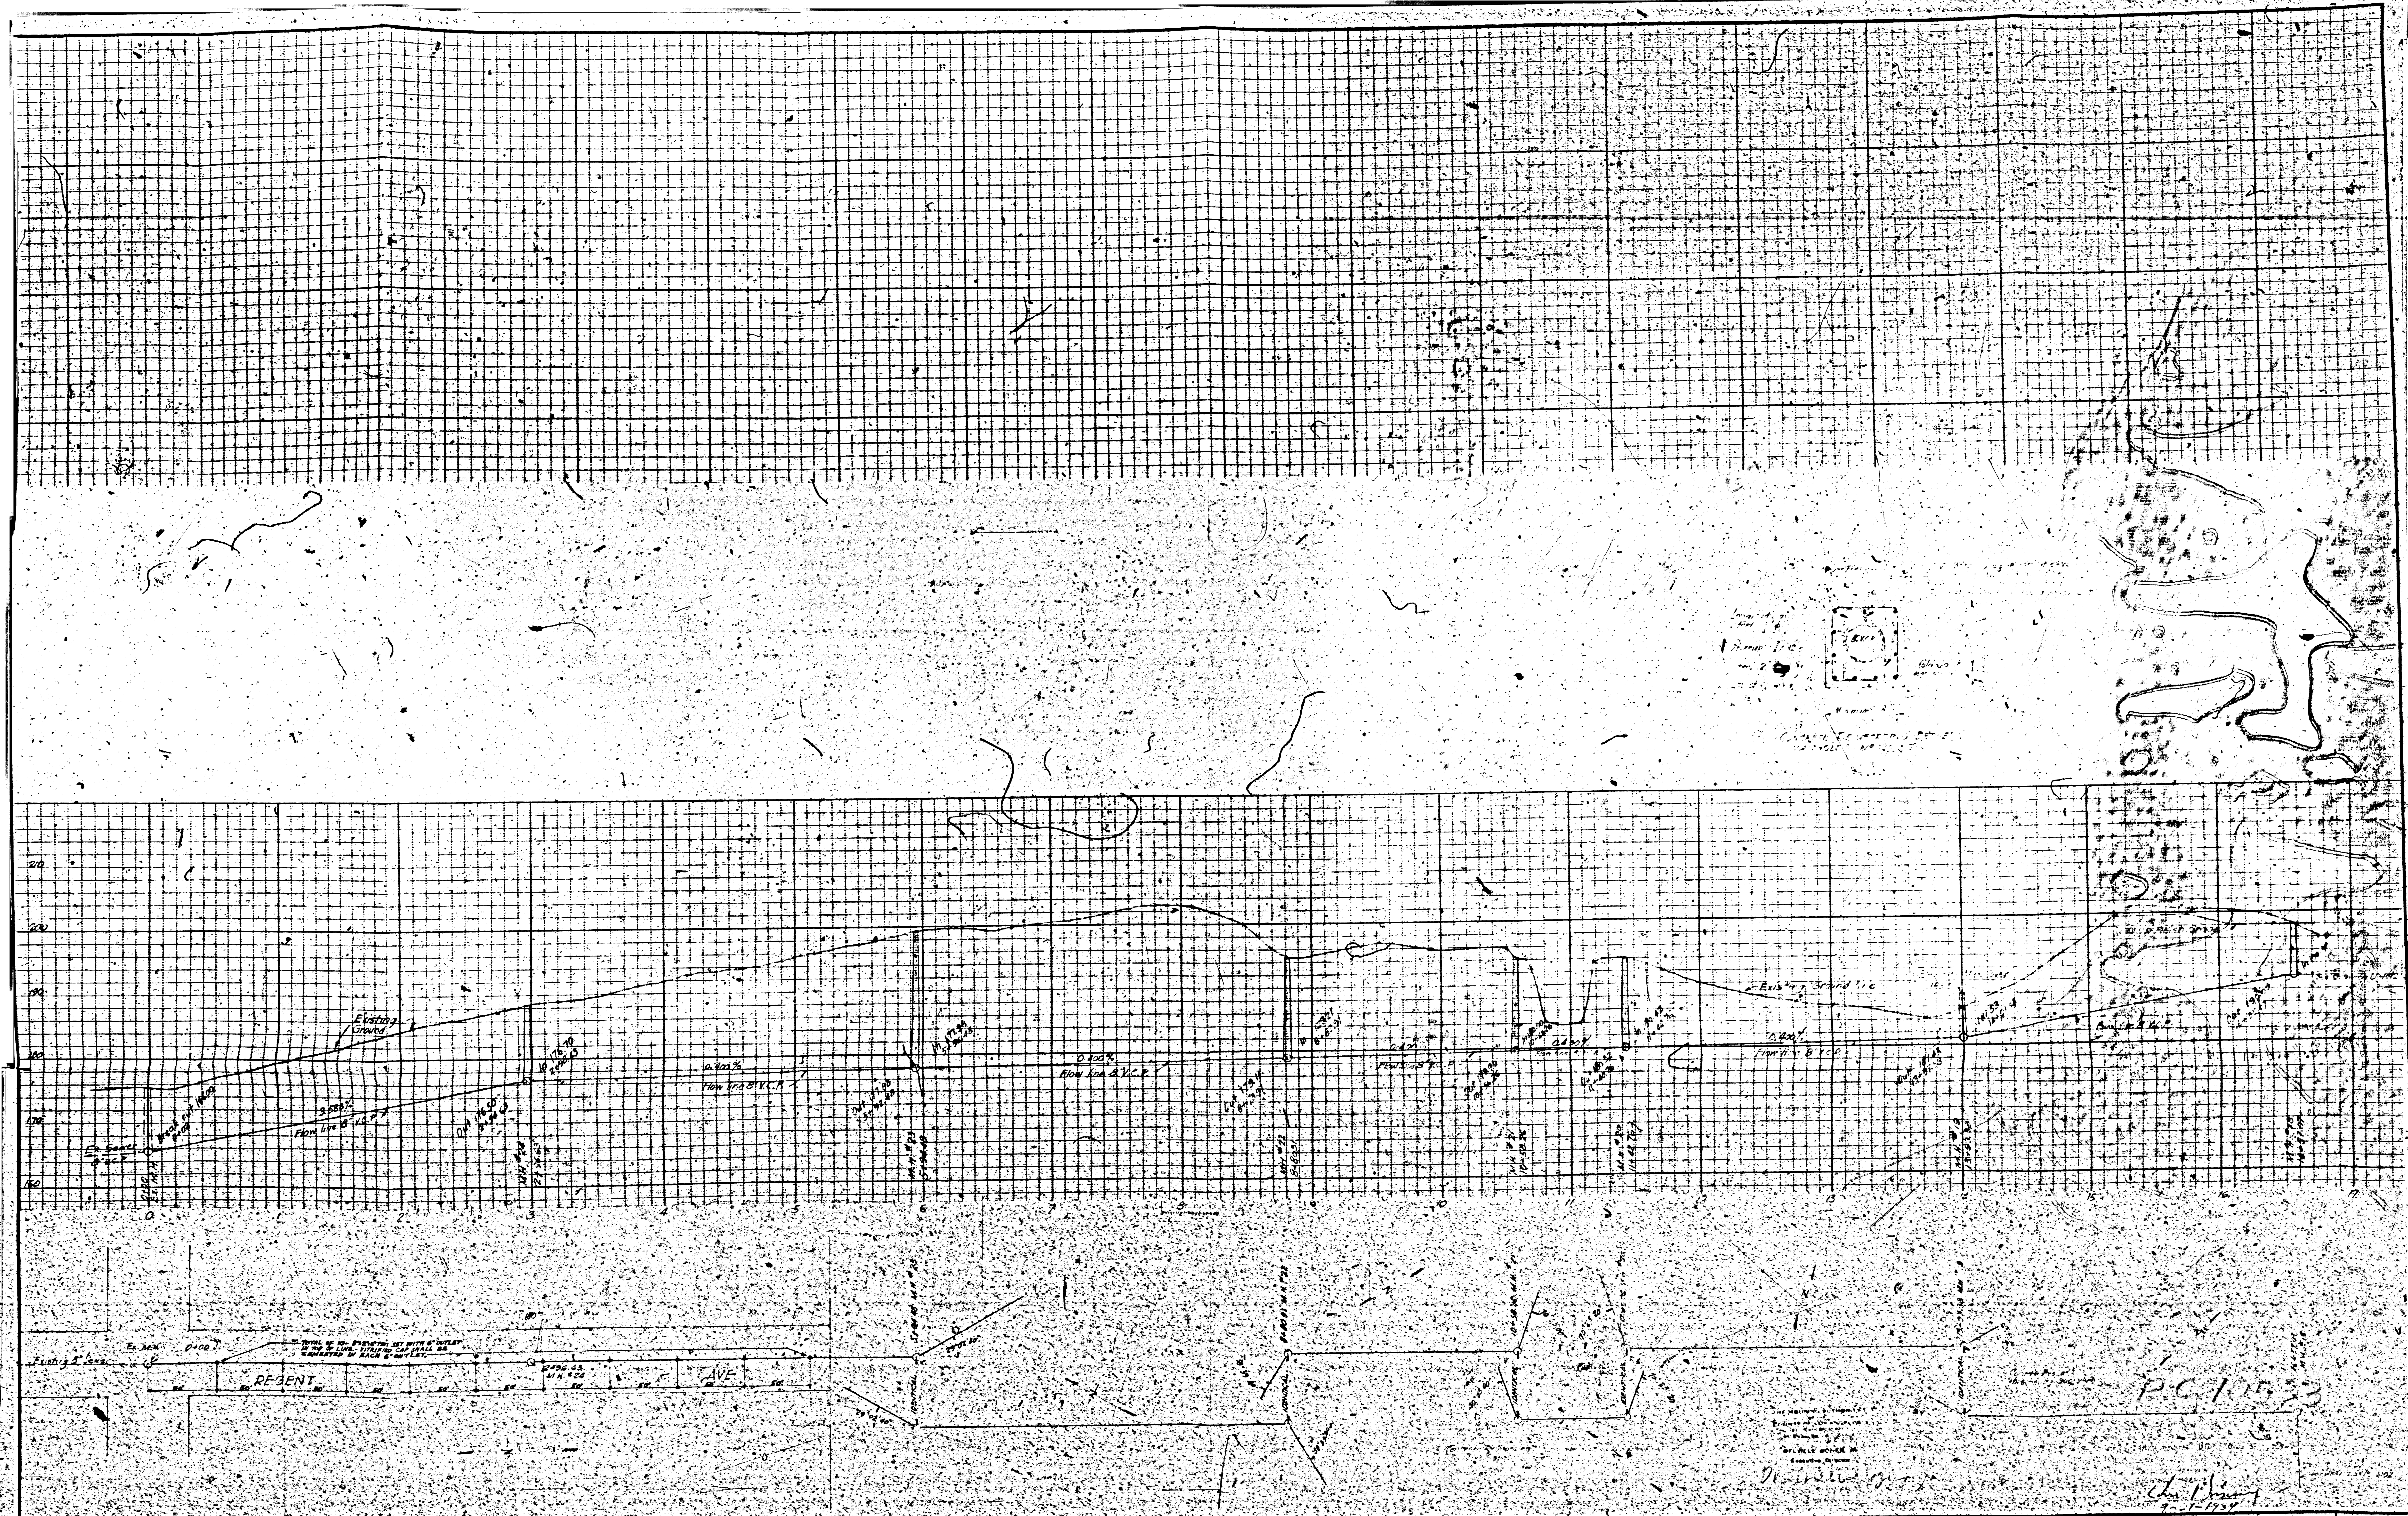

CHALMERS & BARNETT
 CIVIL ENGINEERS
 35 SOUTH RAYMOND AVE.
 PASADENA, CALIFORNIA

KATHERINE BASHFORD
 FRED BARLOW, JR.
 LANDSCAPE ARCHITECTS
 816 WEST FIFTH STREET
 LOS ANGELES, CALIFORNIA

ELLIOTT-LEE ELLINGWOOD
 MECHANICAL & ELECTRICAL
 ENGINEER
 124 WEST FOURTH STREET
 LOS ANGELES, CALIFORNIA

HOWARD G. SMITS
 STRUCTURAL ENGINEER
 300 WIGMORE DRIVE
 PASADENA, CALIFORNIA

HARBOR HILLS HOUSING PROJECT
 THE HOUSING AUTHORITY OF THE COUNTY OF LOS ANGELES, CALIFORNIA
 COMMISSIONERS: ISIDORE B. DOCKWEILER, CHAIRMAN; W. A. SIMPSON, VICE-CHAIRMAN; ROBERT WAYNE BURNS, MRS. MARGARETE L. CLARK, JOSEPH E. SCHUMACHER
 MELVILLE DOZIER, JR., EXECUTIVE DIRECTOR

ASSOCIATED ARCHITECTS
 816 WEST FIFTH STREET, LOS ANGELES, CALIFORNIA
 REGINALD D. JOHNSON, F.A.A., CHIEF ARCHITECT
 CLARENCE S. STEIN, F.A.A., CONSULTING ARCHITECT

SANITARY SEWER SYSTEM
 CONNECTION WITH COUNTY SEWER
 DATE: 7-1-57

U.S.N.A.
 CAL 2-2
 SHEET NO.
1106