



PLUMBING SYMBOLS & ABBREVIATIONS				PLUMBING FIXTURE SCHEDULE			
SYMBOL	INDICATES	SOIL OR WASTE	FIXTURE	ITEM	SIZE	W.C.	W.C.
=====		HORIZONTAL VENT	WATER CLOSET	WC	4"	21 1/2"	1"
-----		COLD WATER	URINAL	UR	2"	2"	3/4"
-----		HOT WATER	LAVATORY	LA	2"	1 1/2"	1/2"
-----		GAS	LAVATORY	LA	2"	1 1/2"	1/2"
-----		EXISTING COLD WATER	CLASSROOM SINK	CS	2"	1 1/2"	1/2"
-----		EXISTING GAS	SERVICE SINK	SS	2"	1 1/2"	1/2"
-----		EXISTING SOIL OR WASTE	SEWAGE SINK	SE	2"	1 1/2"	1/2"
-----		TEMPERED WATER	DRINKING FOUNTAIN	DF	2"	1 1/2"	1/2"
S.O.V.	INDICATES	SHUT-OFF VALVE	DRINKING FOUNTAIN	DF	2"	1 1/2"	1/2"
CONN.		CONNECTION	FLOOR DRAIN	FD	8"	2"	0"
C.O.		CLEAN OUT	FLOOR DRAIN	FD	8"	2"	0"
C.I.		CAST IRON	ROOF DRAIN	RD	3"	0"	0"
C.W.		COLD WATER	DRINK. FOUNT.	DF	2"	1 1/2"	1/2"
H.W.		HOT WATER	SINK	S	2"	1 1/2"	1/2"
V.C.		VITRIFIED CLAY	SHOWER & DEAN	SD	2"	2"	1 1/2"
P.T.		PLUGGED TEE	GROUP SHOWER	SG	0"	0"	1 1/2"
F.H.C.		FIRE HOSE CABINET	FLOOR SINK	FS	2"	2"	0"
F.E.		FIRE EXTINGUISHER					
INVEL		INVEL ELEVATION					
G.		GAS					
EXINT		EXISTING					
F-F		FIRE LINE					
D.S.		DOWNSPOUT					
⊖		THERMOSTAT					

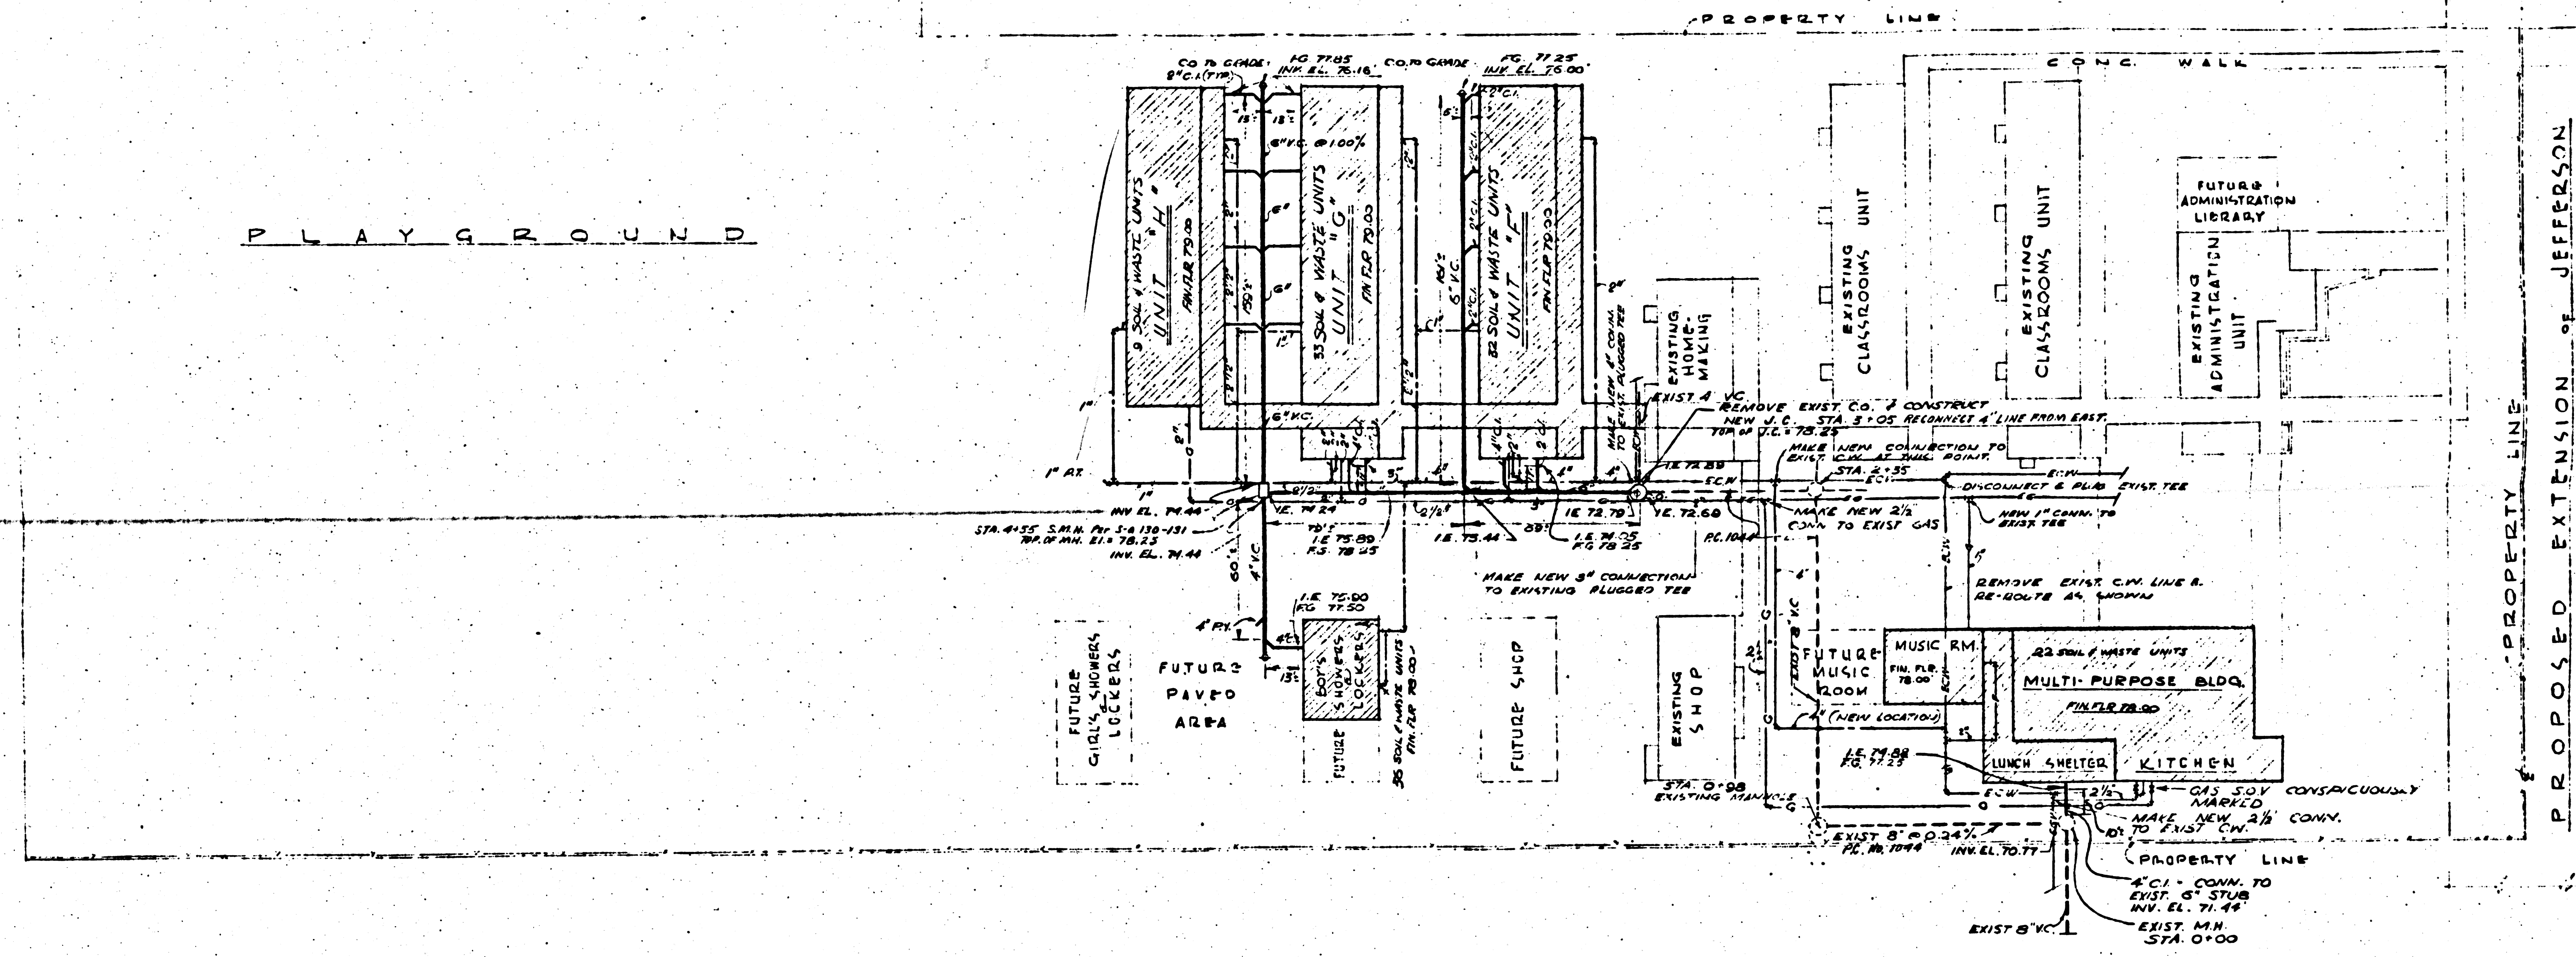

PLOT PLAN
SCALE: 1" = 40'-0"

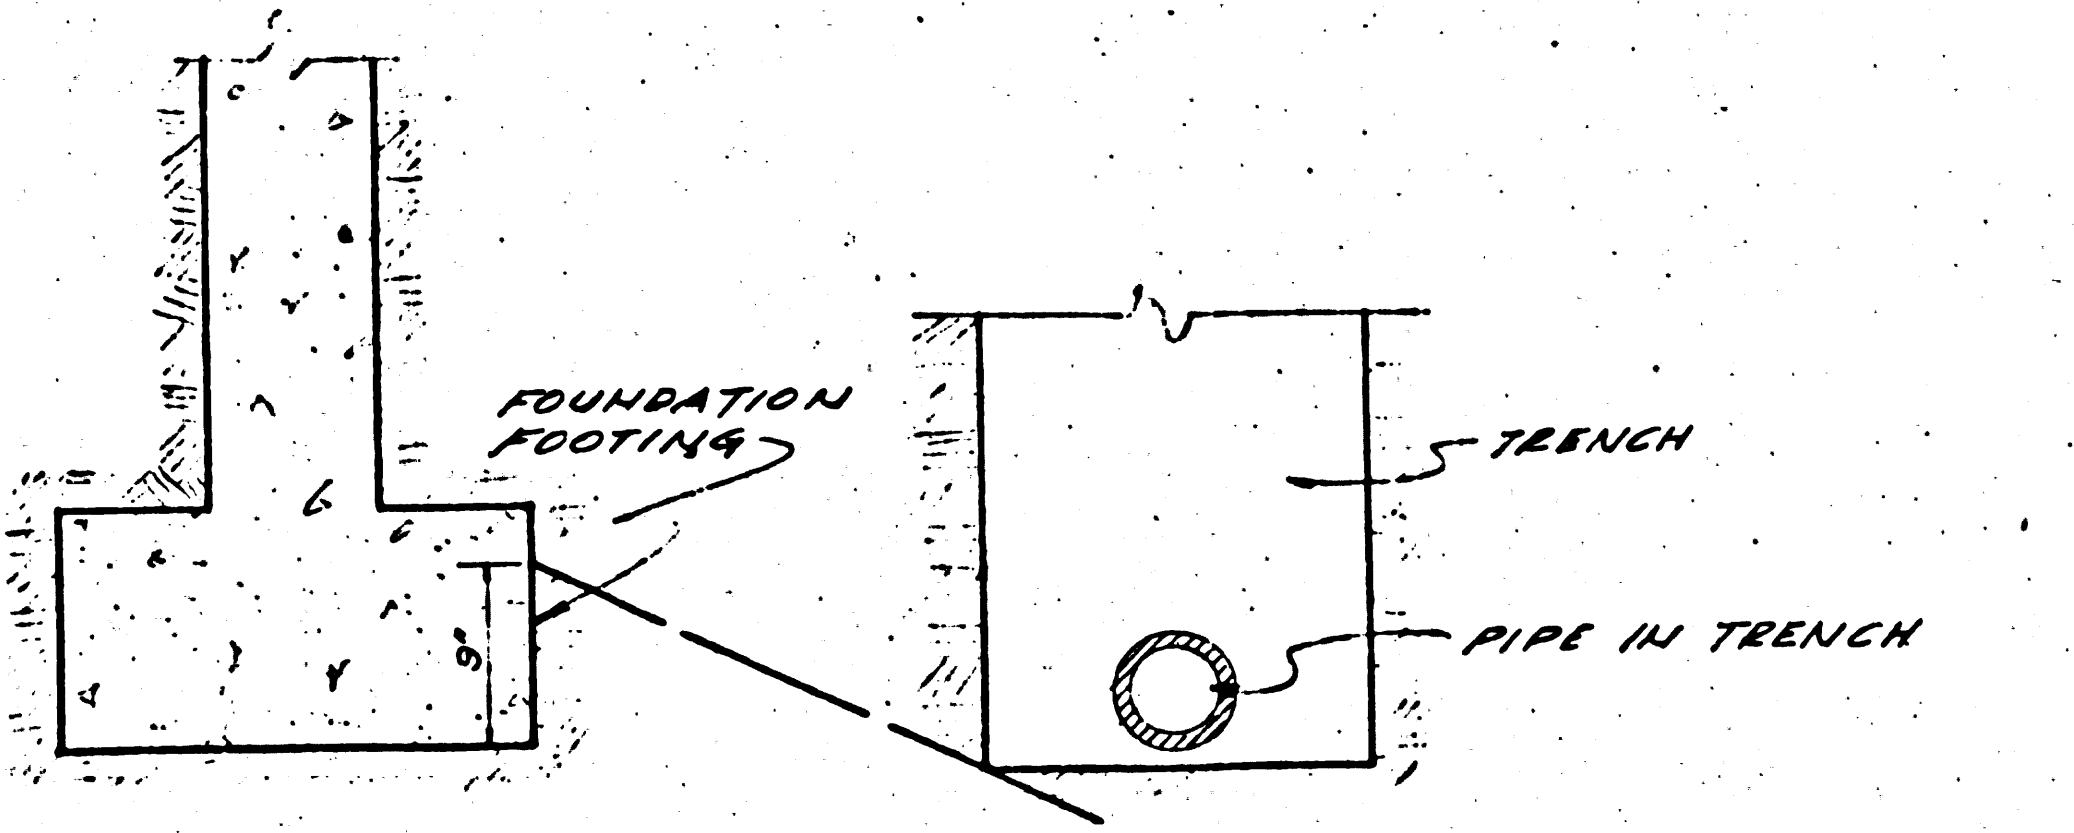

DETAIL OF PIPE TRENCH NEAR FOUNDATION
NOT DRAWN TO SCALE

NOTE: ALL STAKING AND GRADE SHEETS REQUIRED FOR SEWER LINES SHALL BE BY CONTRACTOR

PRIVATE CONTRACT
JOB NUMBER 1640
WALL SHEET 3742
33

LOS ANGELES COUNTY GENERAL SEWER - NOTES

APPROVAL OF SUB-MINIMUM GRADES OBTAINED, PROVIDED SEWER IS STICED AND GRADES SHEETS PLACED.

ALL CONNECTIONS MUST COMPLY WITH COUNTY SEWER ORDINANCE NO. 1305.

HOUSE CONNECTION PERMITS MUST BE TAKEN OUT BEFORE CONSTRUCTION FOR ALL 6" AND 4" LINES.

CONSTRUCTION DIVISION OF THE COUNTY ENGINEERS OFFICE SHALL BE NOTIFIED 24 HOURS PRIOR TO START OF CONSTRUCTION.

APPROVAL OF THIS PLAN APPLIES ONLY 5" x 8" LINE STOPPERS TO BE INSTALLED WITH JOINT COMPANING BY MANUFACTURER AT THIS POINT. SPEC. SEC. 33-66 CONCRETE PAVEMENTS TO BE NOT LESS THAN 2" IN DEPTH WITH CONCRETE SAW. SPEC. SEC. 65

NOTE: ELEVATIONS ARE IN FEET ABOVE CHINA BARRON OR MEAN SEA LEVEL.

THIS DRAWING AND THE DATA HEREON ARE HEREBY MADE A PART OF THE SPECIFICATIONS.

WHICH SHALL BE CONSIDERED ACCORDING TO SPECIFICATIONS ON FILE IN THE OFFICE OF THE COUNTY ENGINEERS AND SHALL BE PROHIBITED ONLY IN THE PRESENCE OF THE COUNTY ENGINEER.

NO WORK SHALL BE STARTED UNTIL THE CONTRACTOR HAS OBTAINED A PERMIT TO EXCAVATE IN CONCRETE FROM THE L.A. COUNTY ROAD DEPARTMENT, 111 SOUTH MAIN STREET.

IF WORK IS TO BE DONE IN A STATE HIGHWAY, A PERMIT MUST BE OBTAINED FROM THE STATE OF CALIFORNIA DIVISION OF HIGHWAYS, 1200 14TH STREET, SACRAMENTO, CALIFORNIA.

APPROVAL OF THIS PLAN BY THE COUNTY OF LOS ANGELES DOES NOT CONSTITUTE A GUARANTEE AS TO THE ACCURACY OF THE LOCATION OF, OR THE DEPTH OF, EXISTING UTILITIES, OR THE LOCATION OF, OR THE DEPTH OF, EXISTING UTILITIES.

1. THE STANDARD MATERIALS SHALL BE AS NOTED.

2. REINFORCE ALL TRENCHES WITHIN FENCED AREA TO MEET LOS ANGELES COUNTY ROAD DEPARTMENT OR CALIFORNIA STATE HIGHWAY, REQUIREMENTS, ACCORDING TO PERMIT.

3. INCLUDE FIVE FEET OF NEWER AT POINTS OF INTERFERENCE WITH EXISTING PIPE.

4. ALL STRUCTURES SHALL BE BRICK SEWER STRUCTURES 8" MIN.

NOTE: NO REPRESENTATIVE OF THE COUNTY ENGINEER WILL SURVEY OR VERIFY ANY CONNECTIONS TO THE WORK.

CONTRACTOR SHALL BE MADE IN THESE PLANS WITHOUT APPEAL OF THE COUNTY ENGINEER.

COUNTY OF LOS ANGELES, CALIFORNIA

APPROVED: [Signature]
COUNTY ENGINEER

APPROVED: [Signature]
JULY ENGINEER OF COUNTY
SALTATION DISTRICT No. 2

MAY 23 1961
OFFICE ENGINEER

CHECKED: [Signature]
OFFICE OF COUNTY ENGINEER, S. & B. 6012

STATE OF CALIFORNIA - DEPARTMENT OF PUBLIC WORKS DIVISION OF ARCHITECTURE R 6 0 1 APPROVED MAY 21 1961 ARCHITECT: [Signature] ARCHITECT	CONTRACTOR TO VERIFY ALL DIMENSIONS AT THE JOB MECHANICAL PLUMBING PLAN DATE: FEB 20 1961 BY: [Signature] CHECKED BY: [Signature] KISTNER, CURTIS & WRIGHT ARCHITECTS AND ENGINEERS LOS ANGELES, CALIF. SAN DIEGO, CALIF.
--	--

PC 1640

NOTE: ALL GAS S.O.V.'S OUTSIDE OF BUILDINGS SHALL BE CONSPICUOUSLY MARKED "GAS"