
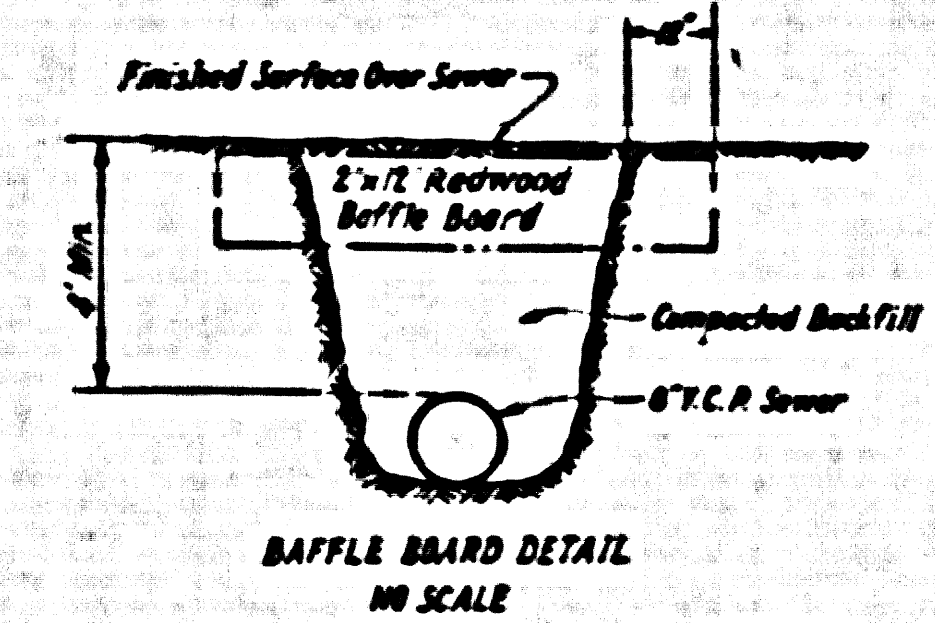


USE STANDARD STRENGTH PIPE EXCEPT AS NOTED.
 USE PLASTISOL FOR ALL VITRIFIED CLAY PIPE JOINTS.
 ALL STRUCTURES SHALL BE BRICK SEWER STRUCTURES AS PER PLAN NO. S-a-104
 USE STANDARD MANHOLE FRAMES AND COVERS AS PER PLAN NO. S-a-117.
 CONSTRUCTION IN LONG BEACH FREEWAY SHALL CONFORM WITH STATE HIGHWAY PERMIT.
 USE FORMULA NO. L.S.E. 54 OF SPECIFICATIONS TO COMPUTE ALLOWABLE LEAKAGE.
 THE CONTRACTOR SHALL NOTIFY THE CONSTRUCTION DIVISION BY TELEPHONE MAILBOX 9-4747, EXT. 01551 AT LEAST 24 HOURS BEFORE STARTING ANY WORK UNDER THIS CONTRACT.
 LOS ANGELES COUNTY STANDARD SEWER SPECIFICATIONS DATED OCTOBER 10, 1960 APPLY IN THE CONSTRUCTION OF THIS PROJECT.
 APPROVAL OF THIS PLAN BY THE COUNTY OF LOS ANGELES DOES NOT CONSTITUTE A REPRESENTATION AS TO THE ACCURACY OF THE LOCATION OF OR THE EXISTENCE OR NON-EXISTENCE OF ANY UNDERGROUND UTILITY PIPE, OR STRUCTURE WITHIN THE LIMITS OF THIS PROJECT.
 ALL MANHOLE TOPS TO BE 18 INCHES ABOVE FINISHED GRADE.

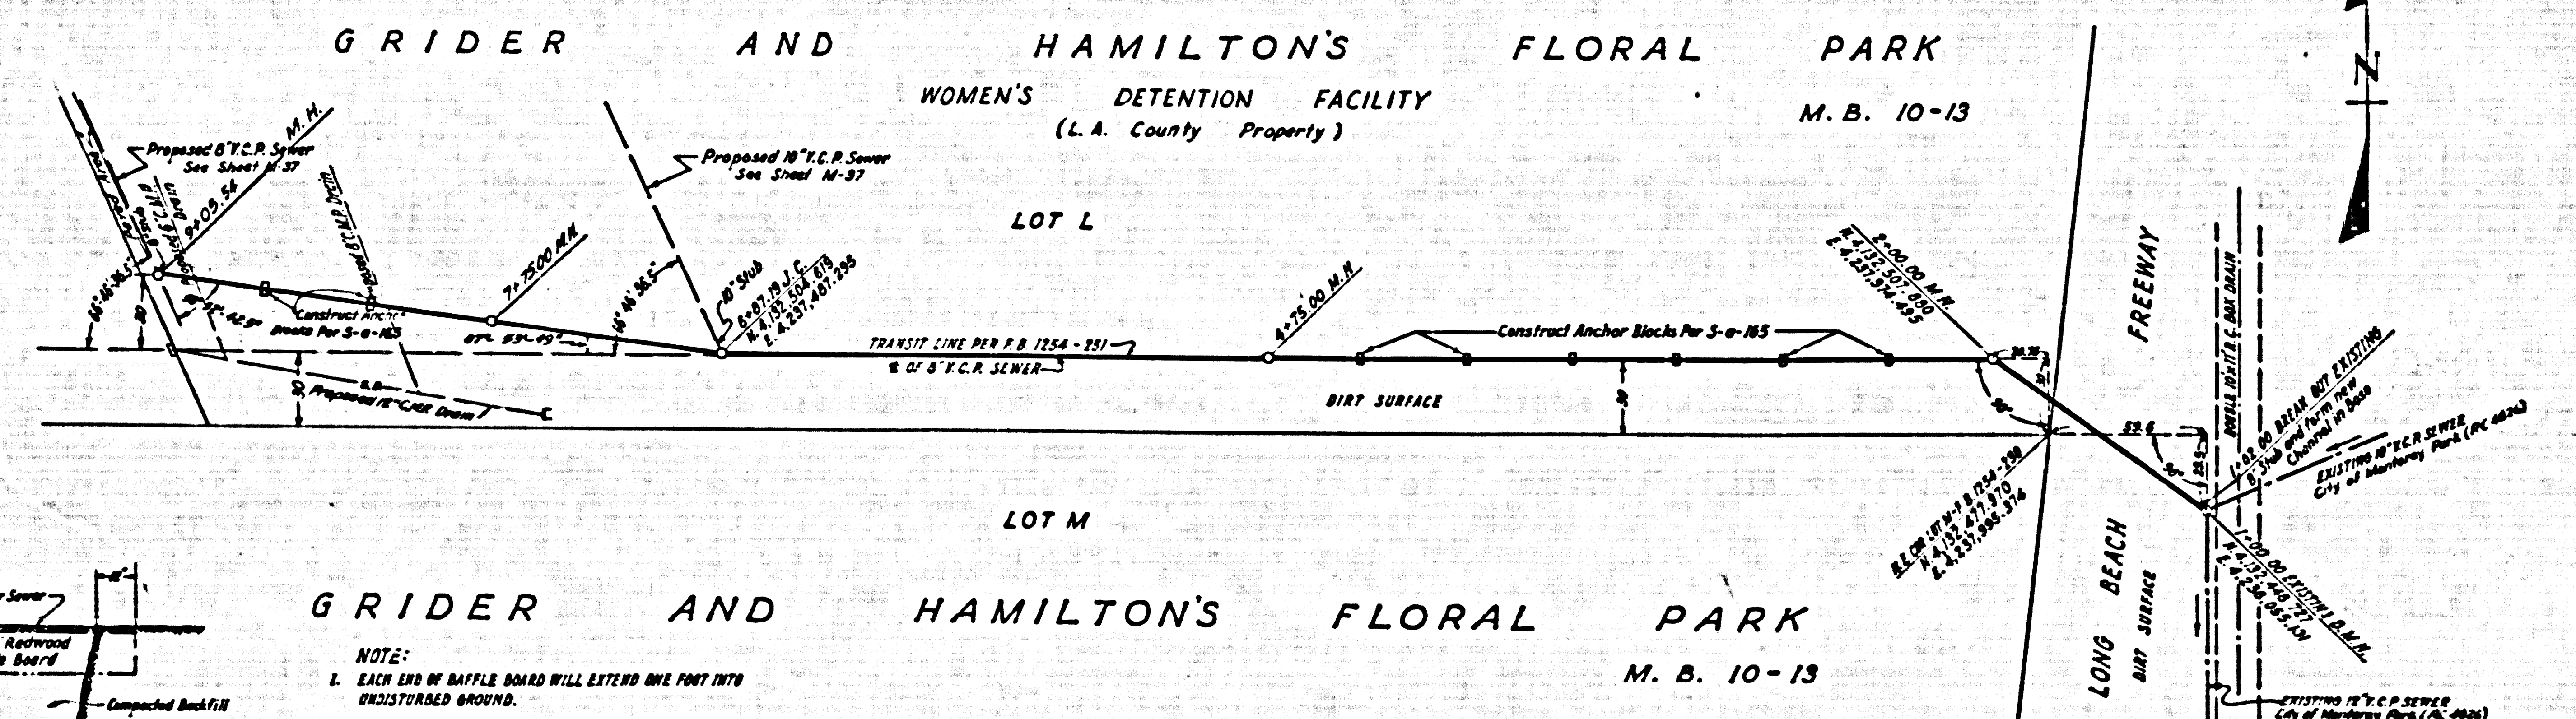

- NOTE:**
1. EACH END OF BAFFLE BOARD WILL EXTEND ONE FOOT INTO UNDISTURBED GROUND.
 2. THE UPPER LAYER OF BACKFILL TO BE ONE FOOT MINIMUM IN THICKNESS. TOPSOIL SHALL BE TAMPED IN PLACE AND PLANTED WITH MUSTARD AND PEE GRASS SEEDS IMMEDIATELY AFTERED UNTIL GROWTH IS RESTORED 3 FROM STATION 1+30 TO 8+00.00
 3. BAFFLE BOARDS SHALL BE SPACED SO THAT THE TOP OF THE LOWER BOARD SHALL BE LEVEL WITH THE BOTTOM OF THE NEXT HIGHER BOARD.

LEGEND
 SEE PLAN NO. S-a-68

NOTE:
 Grades to which this sewer is to be constructed are shown on this Plan and Profile.
 Elevations are in feet above U.S.C. and G.S. Sea Level Datum as of 1929.
 This drawing and the data hereon are hereby made a part of the specifications.
 REIMBURSEMENT CHARGES REQUIRED BY THE CITY OF MONTEREY PARK FOR CONNECTION TO THE SEWER WILL BE PAID DIRECTLY BY THE COUNTY AND IS NOT A PART OF THIS CONTRACT.

SANITARY SEWER FOR WOMEN'S DETENTION FACILITY BISCAILUZ CENTER MONTEREY PARK, CALIFORNIA P.C. 4511 CAP. PROJ. NO. 6457.09

COUNTY OF LOS ANGELES CALIFORNIA
JOHN A. LAMBIE COUNTY ENGINEER

SUBMITTED: [Signature] W.S. 56 APPROVED: [Signature] SANITATION ENGINEER
 APPROVED, CITY OF MONTEREY PARK APPROVED, C.R. COMPTON CHIEF ENGINEER COUNTY ENGINEER DISTRICT NO. 1
 BY: [Signature] BY: [Signature] OFFICE ENGINEER

DESIGNED: YELINER & JAIME TRACED: STANGER CHECKED: YELINER
 SCALE: AS SHOWN DATE: SEPT., 1960 SHEET M-41 OF 41 SHEETS