
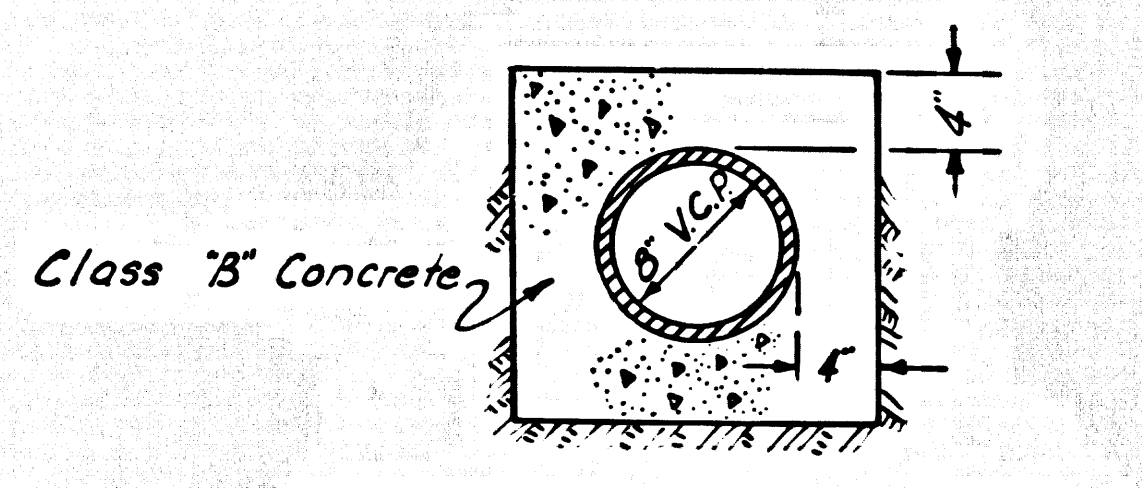



FEDERAL PROJECT No.	FISCAL YEAR	SHEET No.	TOTAL SHEETS
07 LA 60	R 41 / R 8.4		

DATE	REVISION	APPROVED
Nov 1, 1965	Added M.H. @ Sta. 5+25.57	E. Endo

NO CONNECTIONS FOR THE DISPOSAL OF INDUSTRIAL WASTES SHALL BE MADE TO SEWERS SHOWN ON THESE DRAWINGS WITHOUT WRITTEN PERMISSION FROM THE CHIEF ENGINEER AND GENERAL MANAGER OF THE COUNTY SANITATION DISTRICTS.

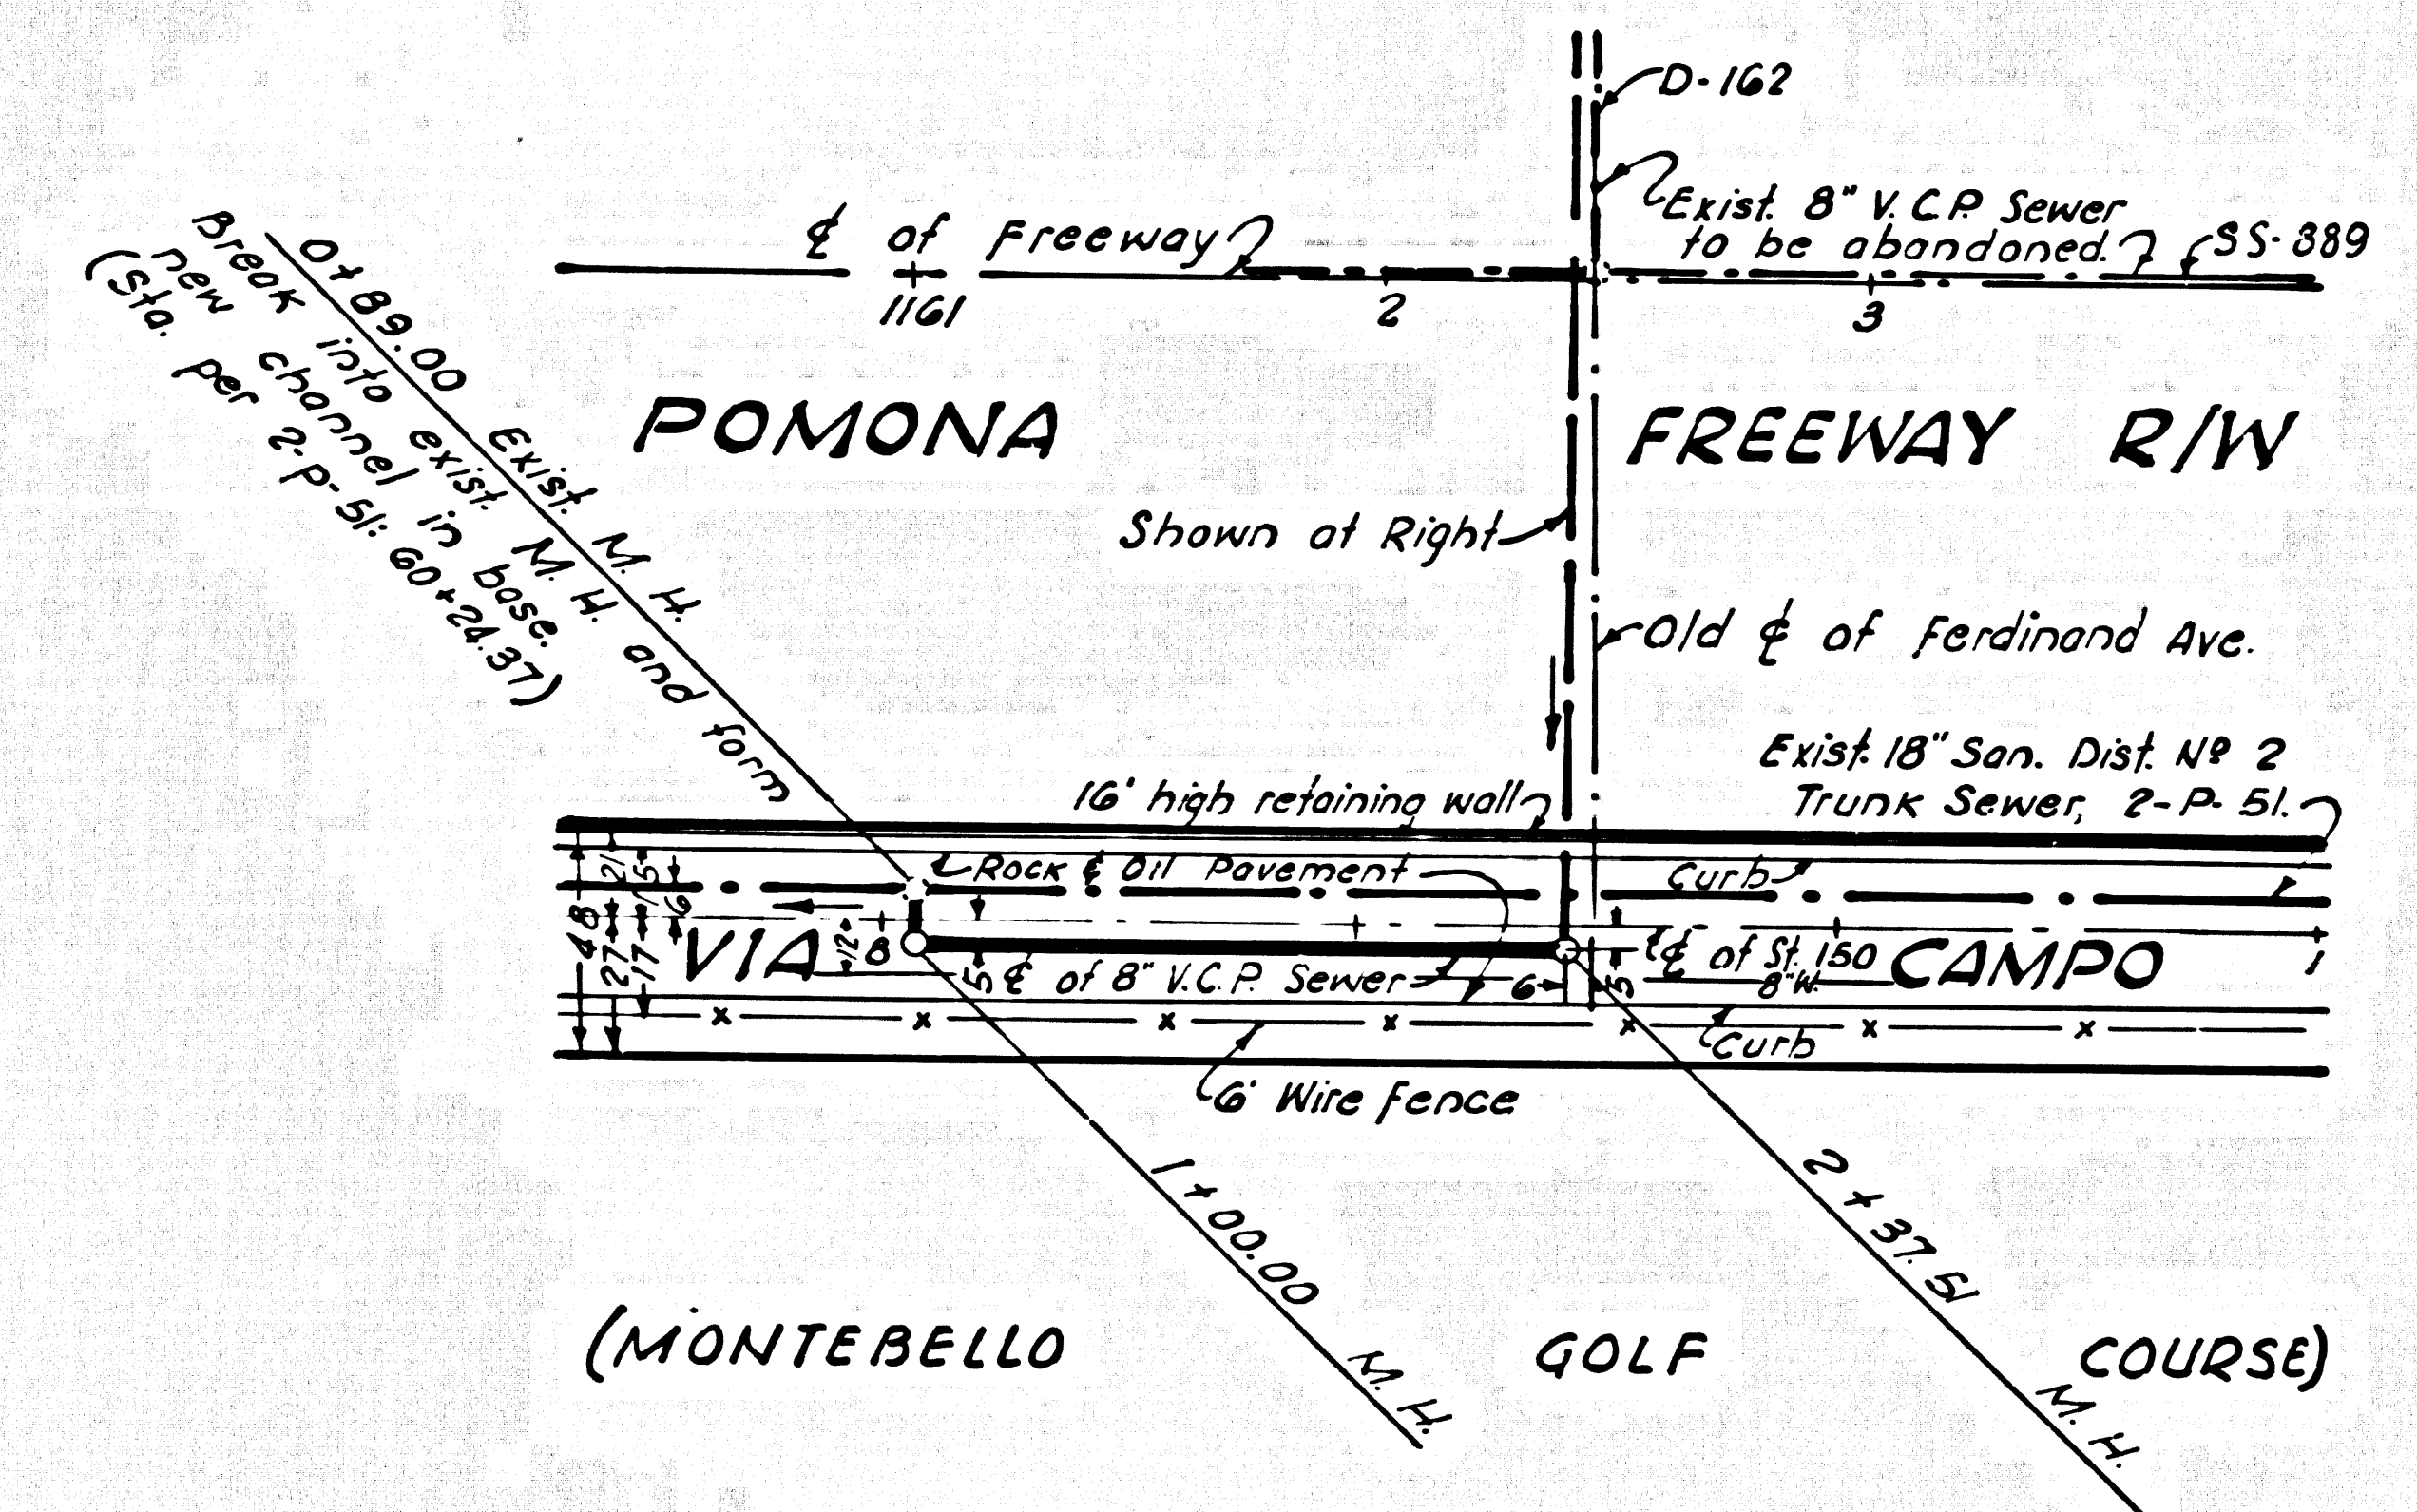

ENCASEMENT DETAIL
SCALE: 1"=1'-0"
Sta. 2+65 TO Sta. 5+23.57

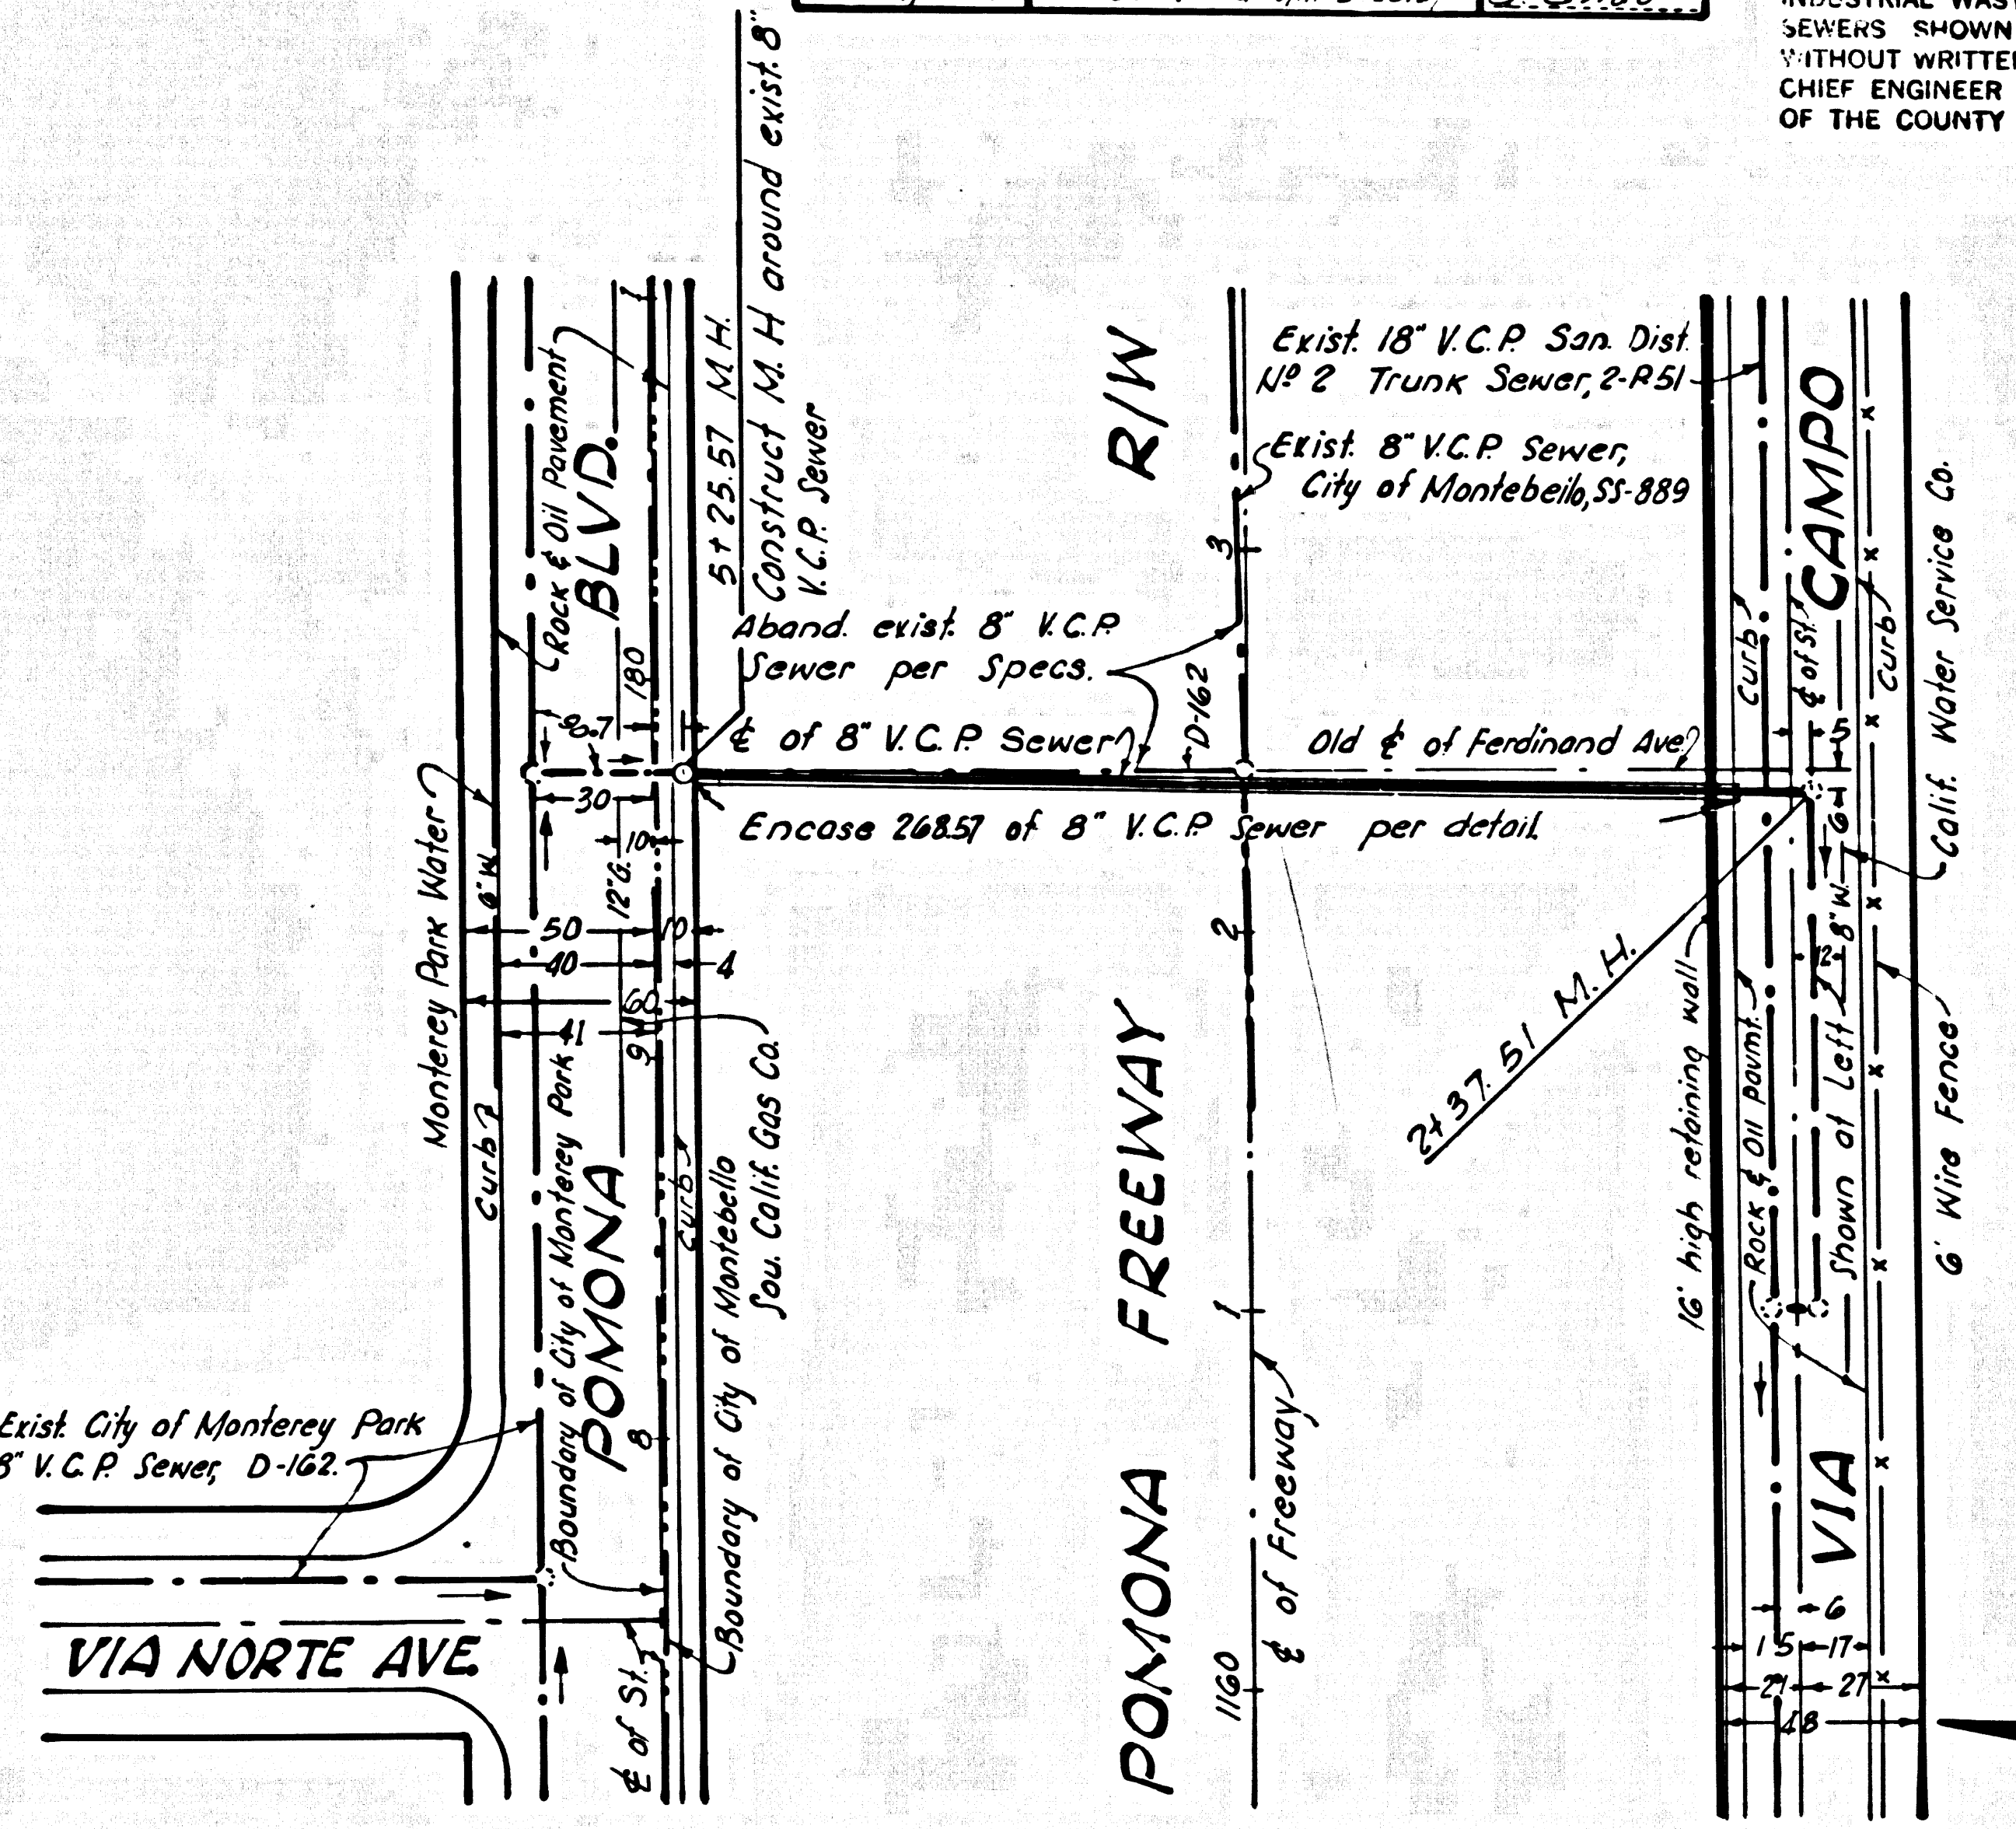

**PLAN AND PROFILE OF
SANITARY SEWERS
R. C. 7484
ONE SHEET**

SCALE: Vert. 1"=5'
Horiz. 1"=50' OCT, 1965

CITY OF MONTEBELLO
APPROVED, JOHN LATHROP, CITY ENGINEER, MONTEBELLO
By: *John Lathrop* 10-21-65
CITY ENGINEER


APPROVED, DAVID L. ATKINSON, CITY ENGINEER, MONTEREY PARK
By: *David L. Atkinson* 10-22-65
CITY ENGINEER

APPROVED, JOHN D. PARKHURST, CHIEF ENGINEER, COUNTY SANITATION DIST. NO. 2
By: *John D. Parkhurst*
OFFICE ENGINEER

NOTE
Contractor shall maintain service of all times during construction of this project.

BEFORE BREAKING INTO ANY EXISTING STRUCTURE, THE CONTRACTOR SHALL OBTAIN WRITTEN PERMISSION FROM THE SANITATION DISTRICT (DU 4-1281) WHICH IS NOTIFIED IN ORDER THAT REQUIRED INSPECTION CAN BE MADE.

Drawn: T. Honda
Checked: W. Miskell

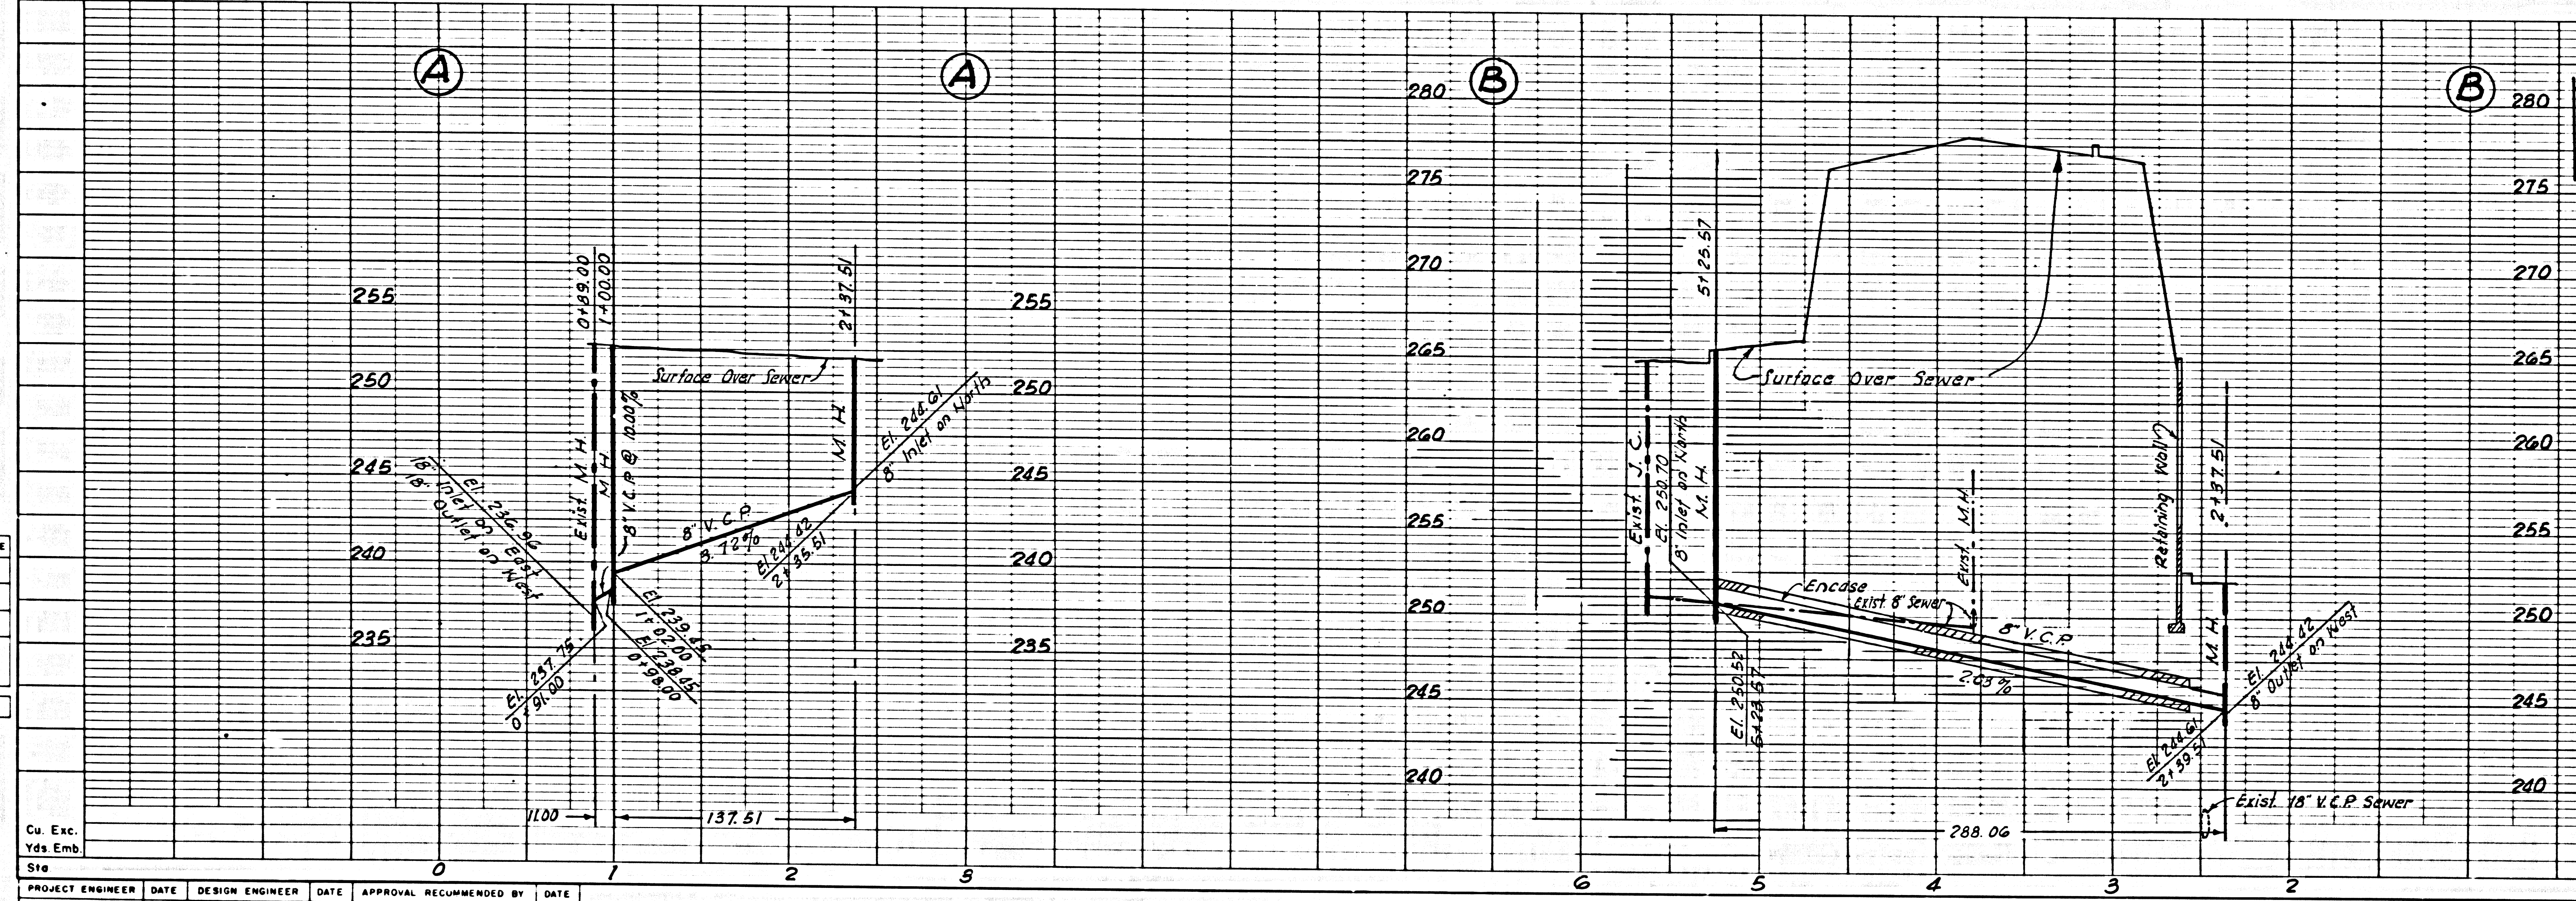

DESIGN DEPT.	INITIAL	DATE
DESIGNED		
TRACED		
CHECKED		
SUPERVISED BY		
RIGHT OF WAY		

PROJECT ENGINEER	DATE	DESIGN ENGINEER	DATE	APPROVAL RECOMMENDED BY	DATE

STATE	FEDERAL PROJECT NO.	FISCAL YEAR	SHEET NO.	TOTAL SHEETS
CALIF.				
COUNTY	ROUTE	POST MILES - TOTAL PROJECT	SHEET NO.	TOTAL SHEETS
07 LA	60	R41/R84		

DATE	REVISION	APPROVED
Nov 1, 1965	Done M.H. @ Sta 5+25.57	E. Engd.

NO CONNECTIONS FOR THE DISPOSAL OF INDUSTRIAL WASTES SHALL BE MADE TO SEWERS SHOWN ON THESE DRAWINGS WITHOUT WRITTEN PERMISSION FROM THE CHIEF ENGINEER AND GENERAL MANAGER OF THE COUNTY SANITATION DISTRICTS.

DEPUTY DISTRICT ENGINEER
APPROVED: _____

PLAN AND PROFILE OF
SANITARY SEWERS
R. C. 7484
ONE SHEET

SCALE: Vert. 1"=5'
Horiz. 1"=50' OCT, 1965

CITY OF MONTEBELLO

APPROVED, JOHN LATHROP, CITY ENGINEER, MONTEBELLO
By: *John Lathrop* 10-21-65
CITY ENGINEER



APPROVED, DAVID L. ATKINSON, CITY ENGINEER, MONTEREY PARK
By: *David L. Atkinson* 10-22-65
CITY ENGINEER

APPROVED, JOHN D. PARKHURST, CHIEF ENGINEER, COUNTY SANITATION DIST. NO. 2
By: *J. D. Parkhurst*
OFFICE ENGINEER



NOTE
Contractor shall maintain service at all times during construction of this project.

BEFORE BREAKING INTO ANY EXISTING STRUCTURE, THE CONTRACTOR SHALL OBTAIN FINAL ACCEPTANCE OF THIS WORK FROM THE COUNTY SANITATION DISTRICT (DU 4.1281) SHALL BE NOTIFIED IN ORDER THAT REQUIRED INSPECTION CAN BE MADE.

Drawn: *T. Honda*
Checked: *K. Miskell*

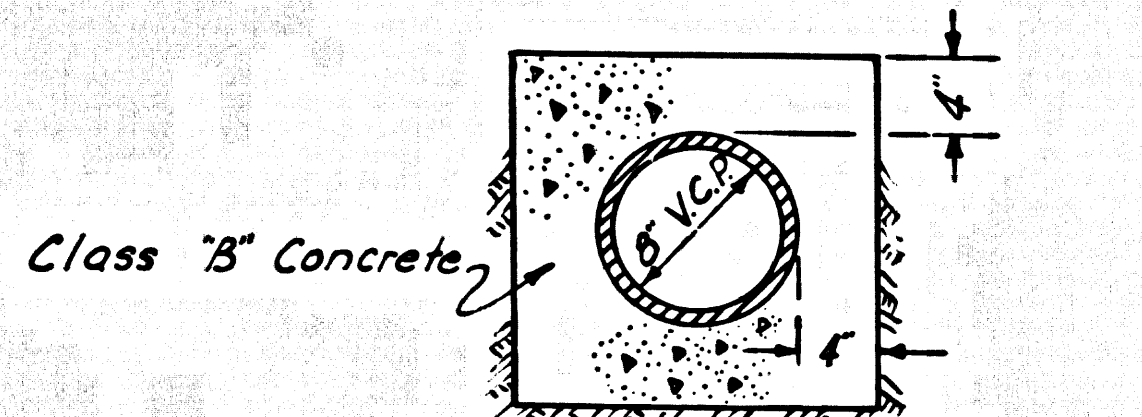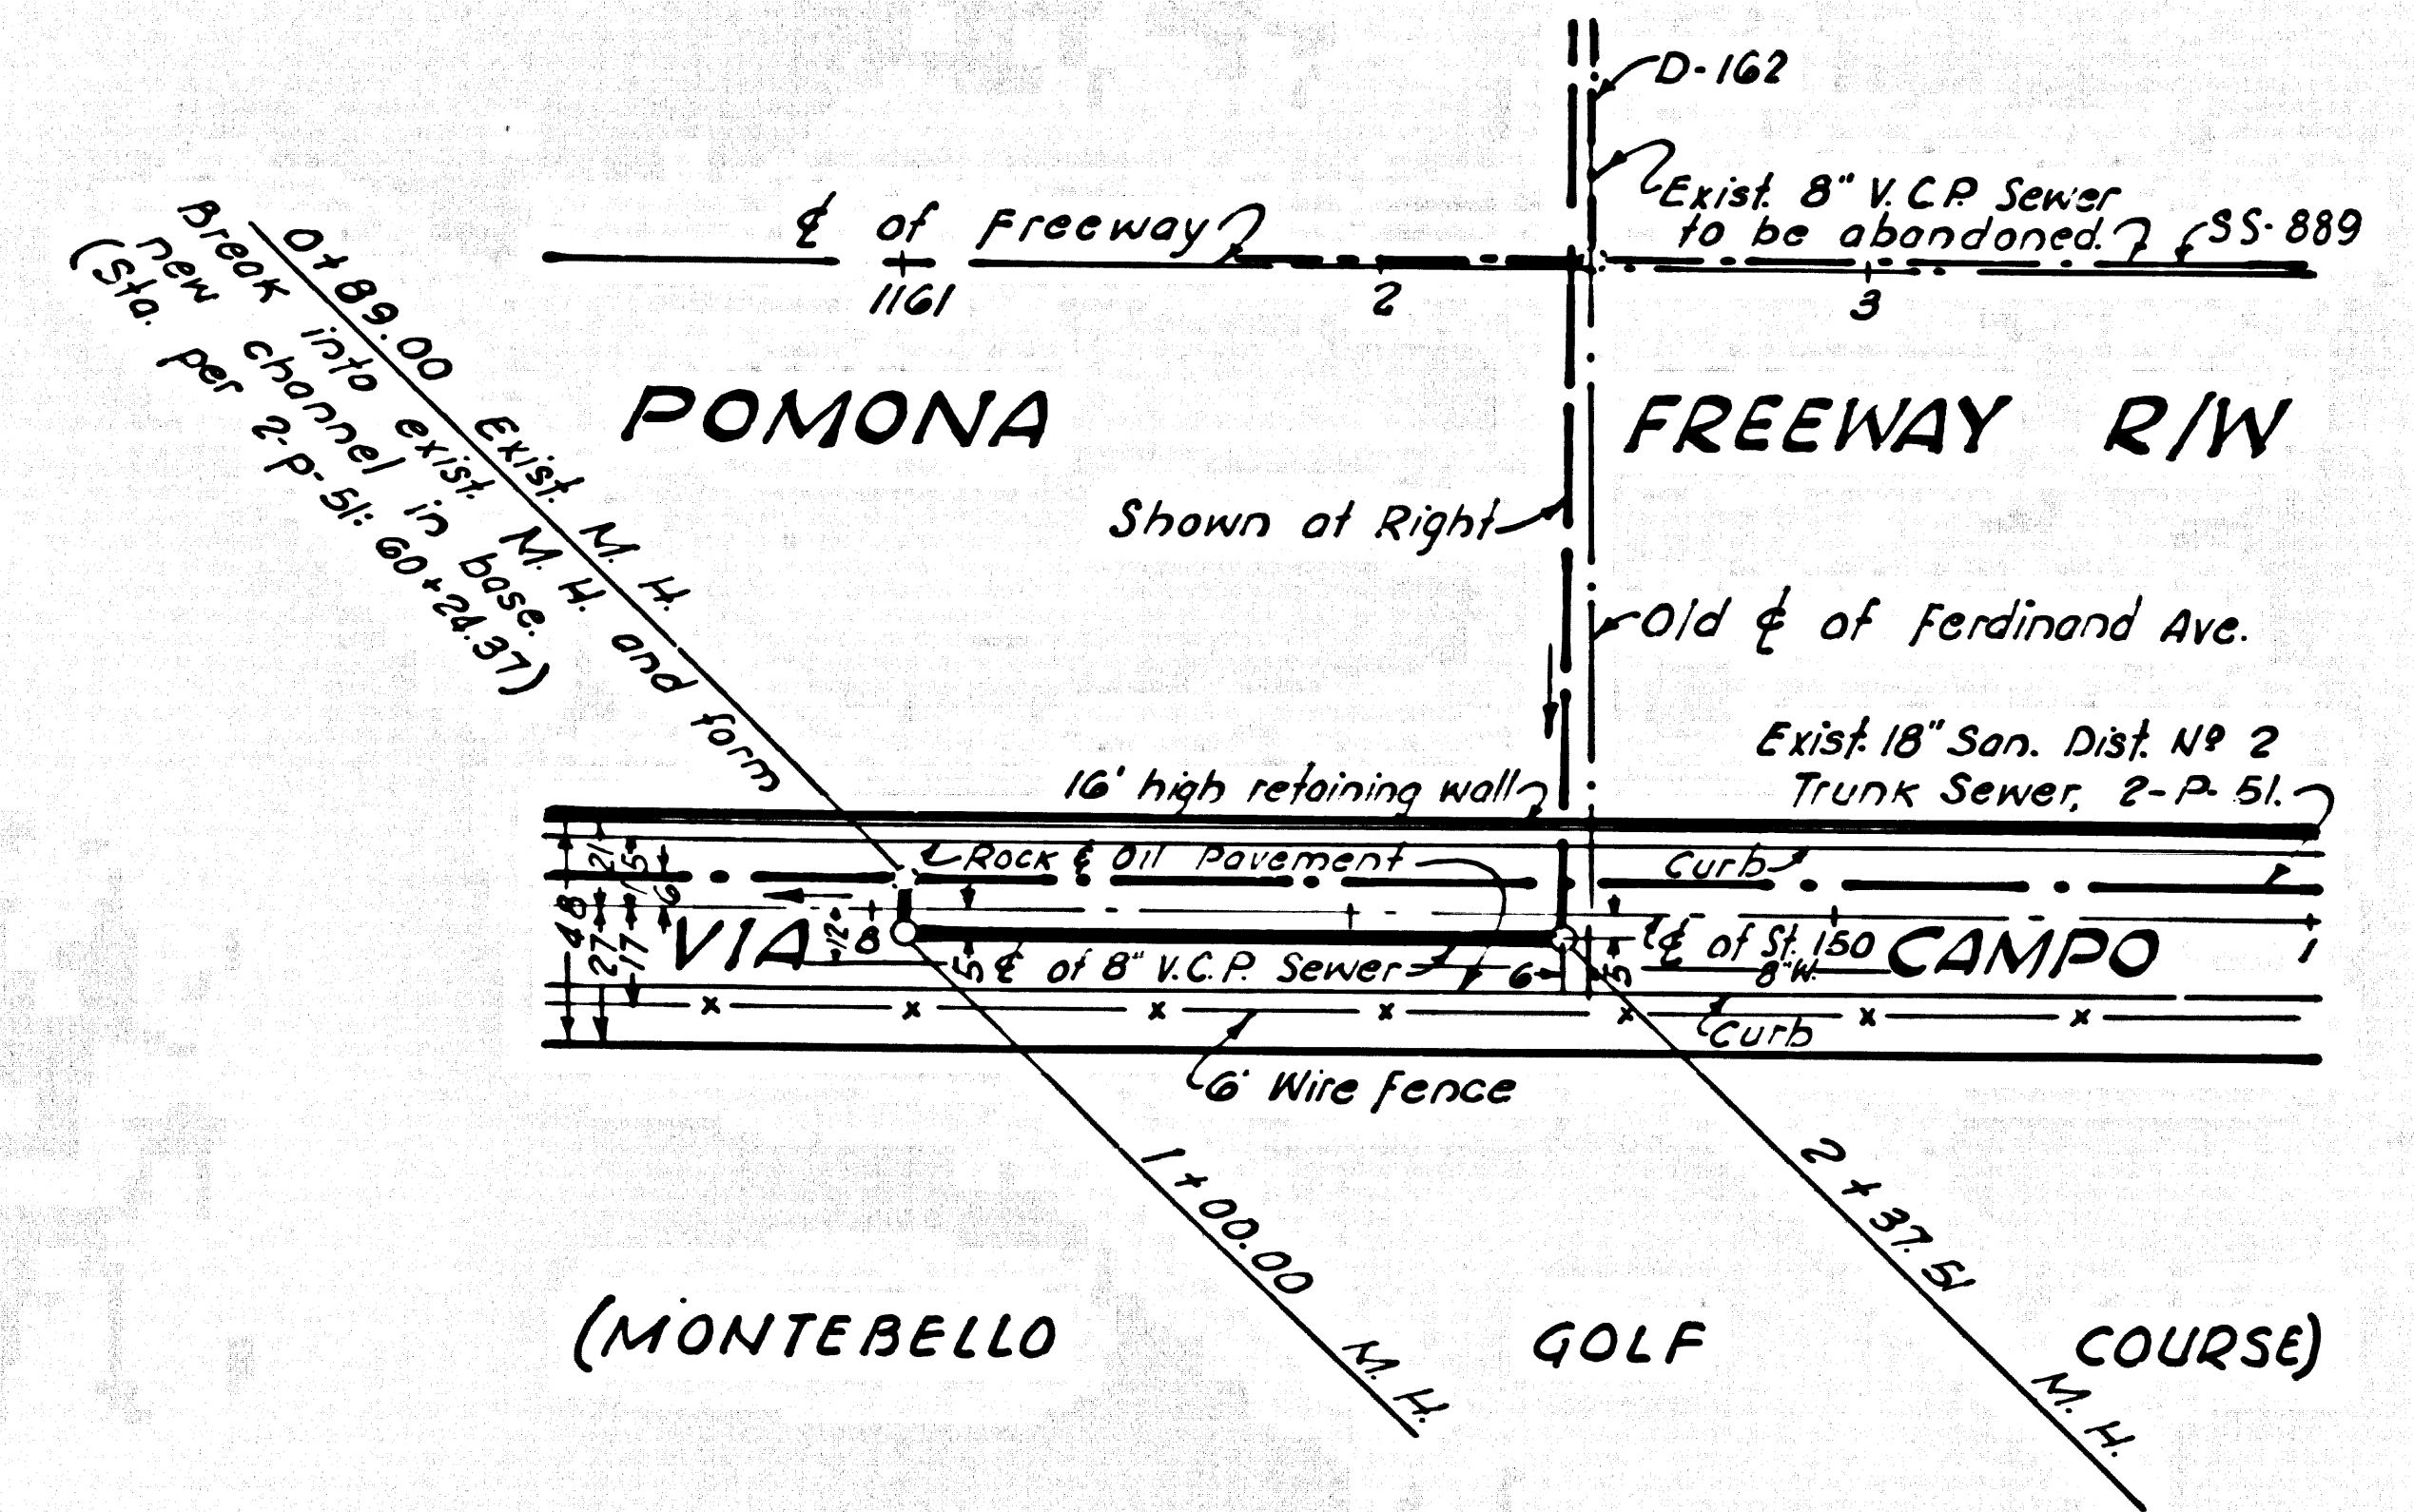

ENCASEMENT DETAIL
SCALE: 1"=1'-0"
Sta. 2+85 TO Sta. 5+23.57

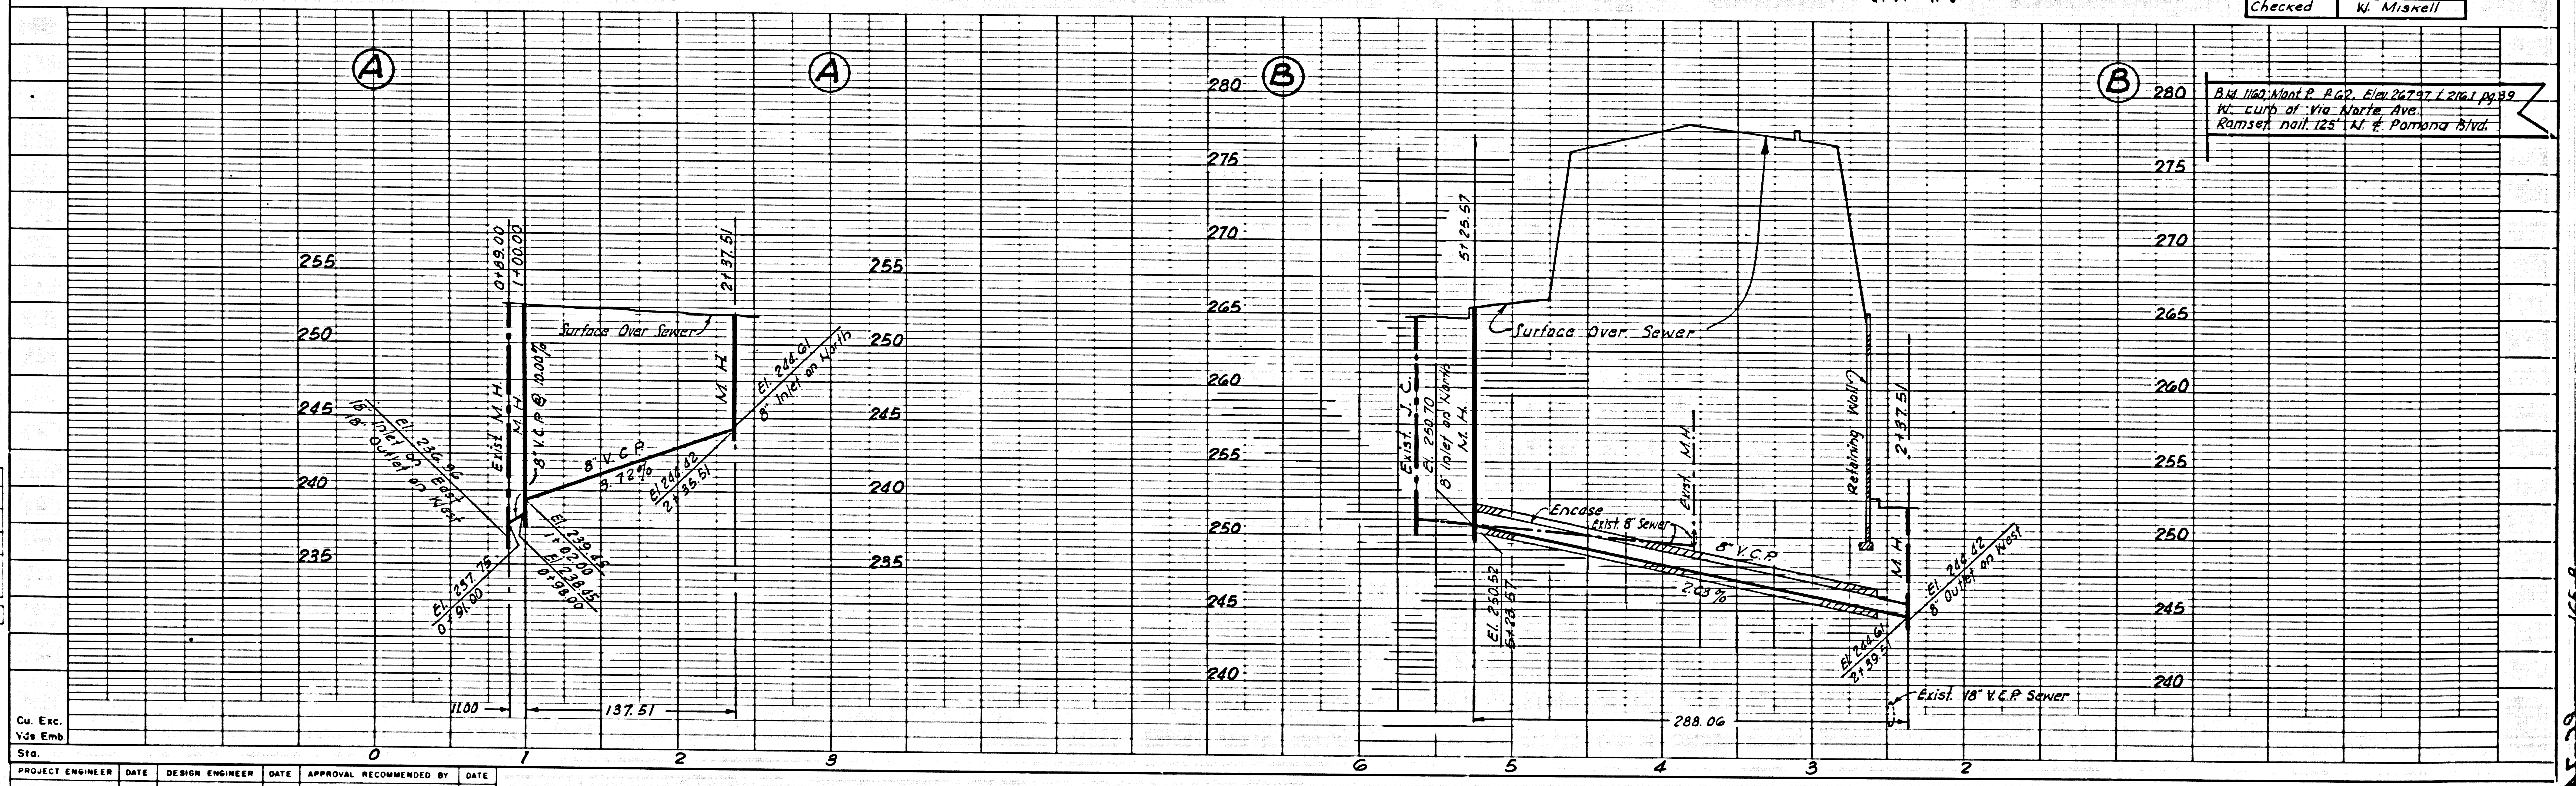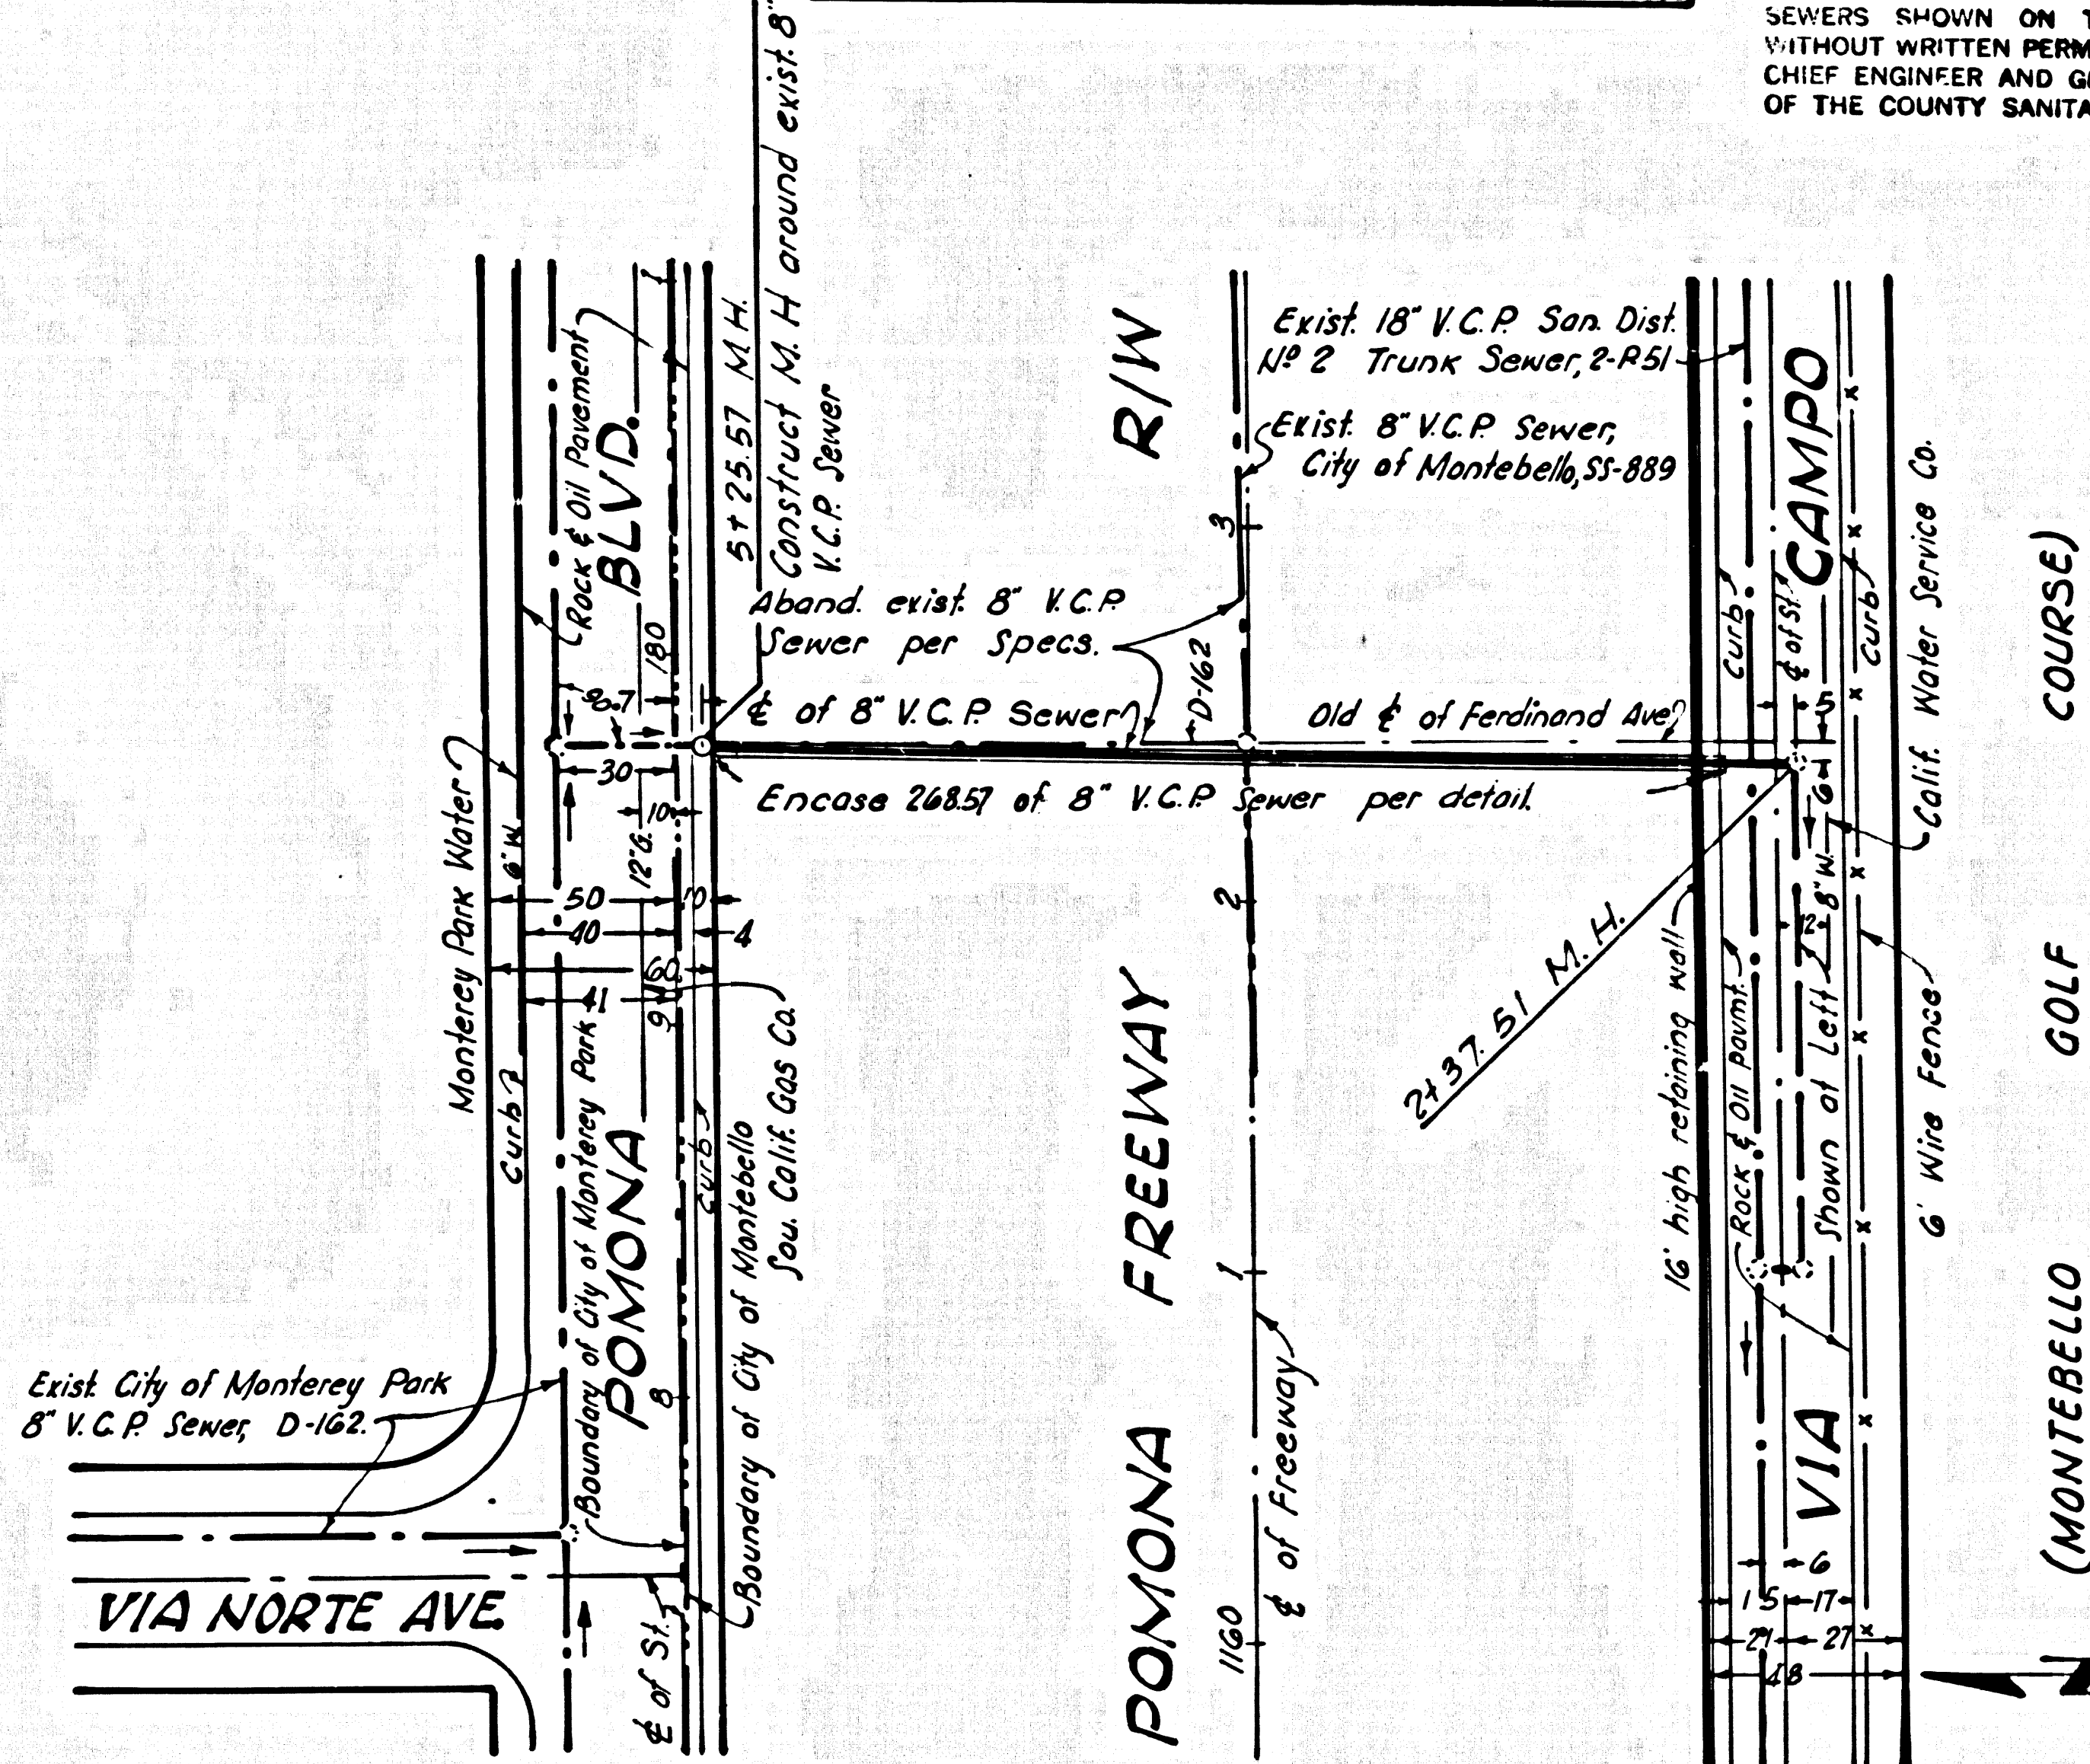

Blk. 110, Mont. P. R. 62, Elev. 267.97, L. 216.1, pg. 39
W. curb of Via Norte Ave.
Ramset nail 125' N. of Pomona Blvd.

DESIGN DEPT.	INITIAL	DATE
DESIGNED		
TRACED		
CHECKED		
SUPERVISED BY		
POINT OF WAY		

PROJECT ENGINEER	DATE	DESIGN ENGINEER	DATE	APPROVAL RECOMMENDED BY	DATE