
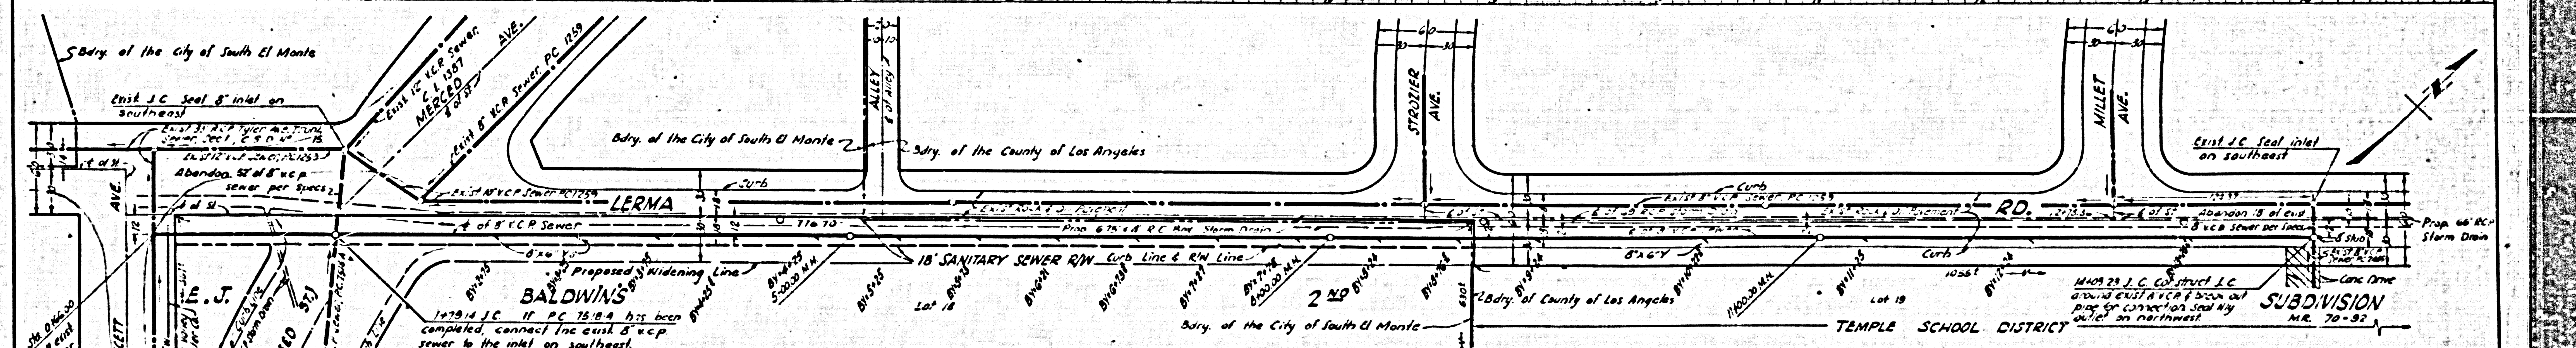


S.M. S.D. 787, 21, 23, 175, FA 3317-8  
 Merced Ave. & Lerma St. N.E. Corner  
 at S.D. 787, 21, 23, 175, FA 3317-8

REIMBURSEMENT CHARGE  
 CALL MAIN OFFICE

39921

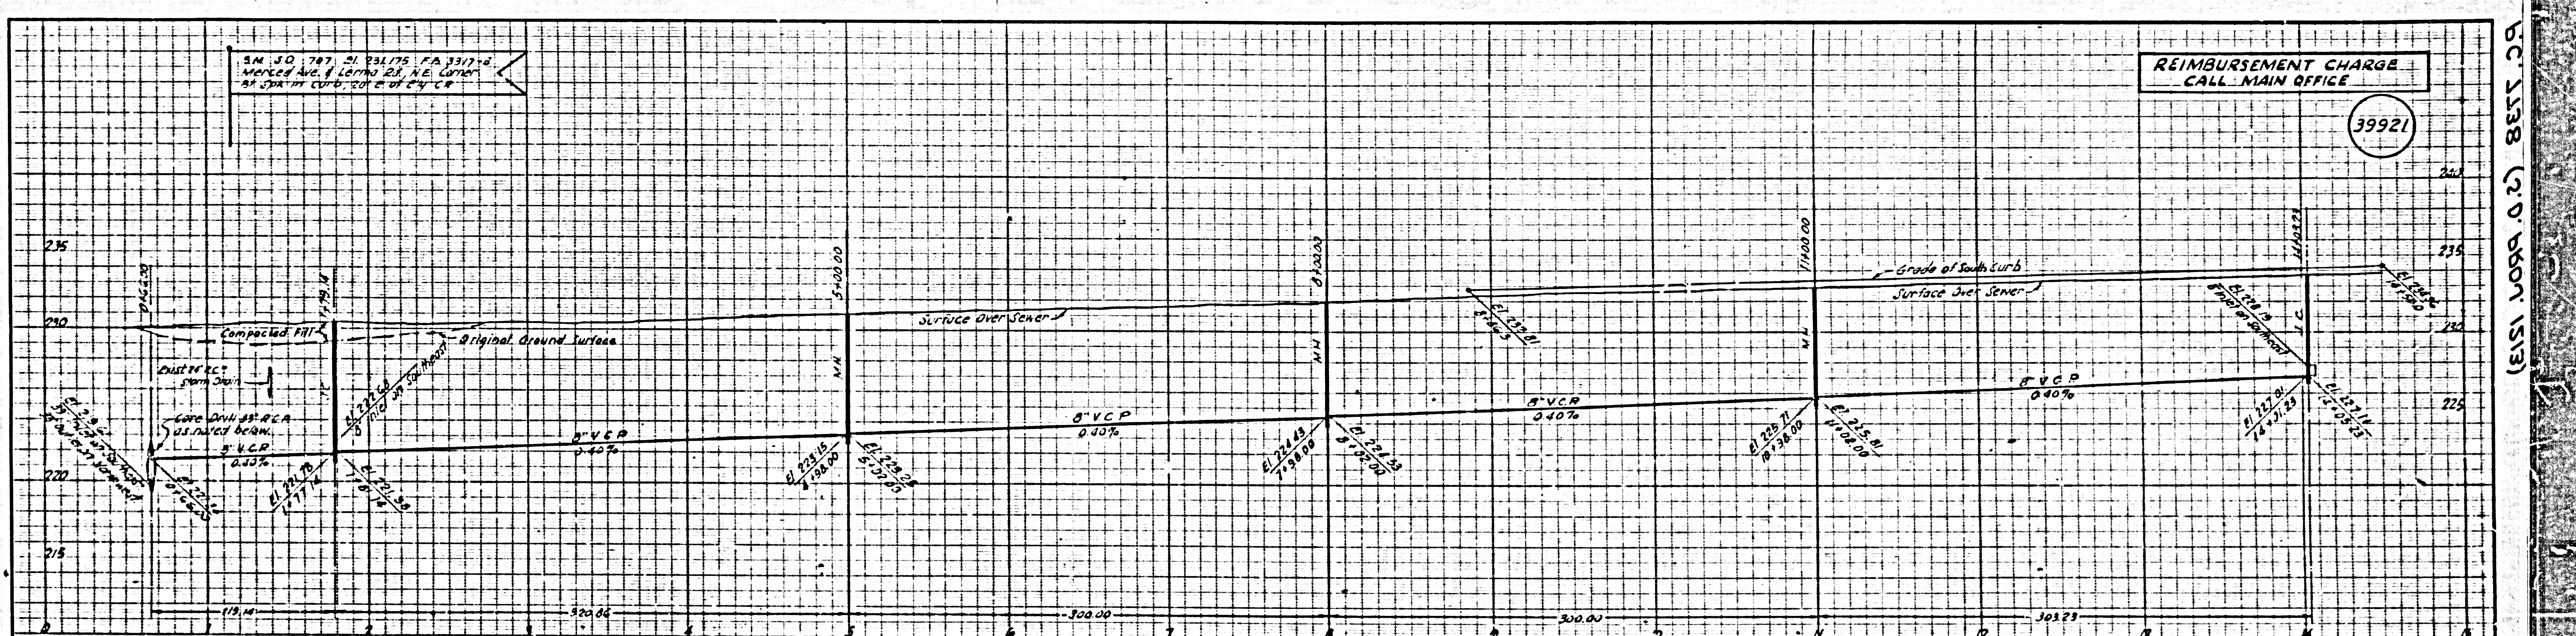

REVISIONS			
NO.	DATE	DESCRIPTION	BY

RE: APPROVAL OF THE SEWER PLANS FOR THIS PROJECT BY THE COUNTY OF LOS ANGELES DOES NOT CONSTITUTE A REPRESENTATION AS TO THE ACCURACY OF THE LOCATION OF OR THE EXISTENCE OR ABSENCE OF ANY UNDERGROUND UTILITY PIPE, OR STRUCTURE WITHIN THE LIMITS OF THIS PROJECT.

NO CONNECTIONS FOR THE DISPOSAL OF INDUSTRIAL WASTES SHALL BE MADE TO SEWERS SHOWN ON THESE DRAWINGS WITHOUT WRITTEN PERMISSION FROM THE CHIEF ENGINEER AND GENERAL MANAGER OF THE COUNTY SANITATION DISTRICTS.

- GENERAL NOTES**
1. FOR LEGEND SEE STANDARD PLAN 5-1
  2. USE EXTRA STRENGTH VITRIFIED CLAY PIPE
  3. USE MECHANICAL COMPRESSION JOINTS FOR ALL VITRIFIED CLAY PIPE SEWERS PER SEC. 56, 405.49 OF STANDARD SEWER SPECIFICATIONS AS REVISED
  4. ALL STRUCTURES SHALL BE BRICK SEWER STRUCTURES AS PER PLAN NY 5-3
  5. USE STANDARD MANHOLE FRAMES AND COVERS AS PER PLAN NY 5-16
  6. USE FORMULA NO. 2, SEC. 58 OF SPECIFICATIONS TO COMPUTE ALLOWABLE LENGTH
  7. RESURFACE TRENCHES WITHIN THE PAVED AREA OF STREETS AS NOTED ON THE STORM DRAIN PLANS
  8. ABANDONED PORTIONS OF MAIN LINE SEWERS OR HOUSE LATERALS SHALL BE SEALED PER SPEC.
  9. SANITARY SEWERS SHALL BE CONSTRUCTED ACCORDING TO STANDARD SPEC. DATED MAY 19, 1962, AS REVISED, ON FILE IN THE OFFICE OF THE COUNTY ENGINEER AND SHALL BE INSPECTED ONLY IN THE PRESENCE OF THE COUNTY ENGINEER
  10. THE CONTRACTOR SHALL NOTIFY THE CONSTRUCTION DIVISION BY TELEPHONE NO. 5-4747 EXT. 2151 AT LEAST 24 HOURS BEFORE STARTING ANY WORK UNDER THIS PROJECT.
  11. NO REVISIONS SHALL BE MADE IN THESE PLANS WITHOUT THE APPROVAL OF THE COUNTY ENGINEER.

1964 STORM DRAIN BOND ISSUE  
 LOS ANGELES COUNTY  
 FLOOD CONTROL DISTRICT  
 STORM DRAIN PROJ. 1213

APPROVED: JOHN A. LAMBIE  
 COUNTY ENGINEER

PREPARED BY:  
**JOHN A. LAMBIE**  
 COUNTY ENGINEER

RECOMMENDED BY:  
**PC. 7138**  
 ALLIANCE ENGINEERING & SURVEYING

STATION: TO STA.  
**PLAN AND PROFILE**

SCALE: DATE: DWG. NO. SHEET 1 OF 1

PLANS 78-17 JUNE 29-59  
 REC-7337 - 69-89

W.S. 37-B-2