
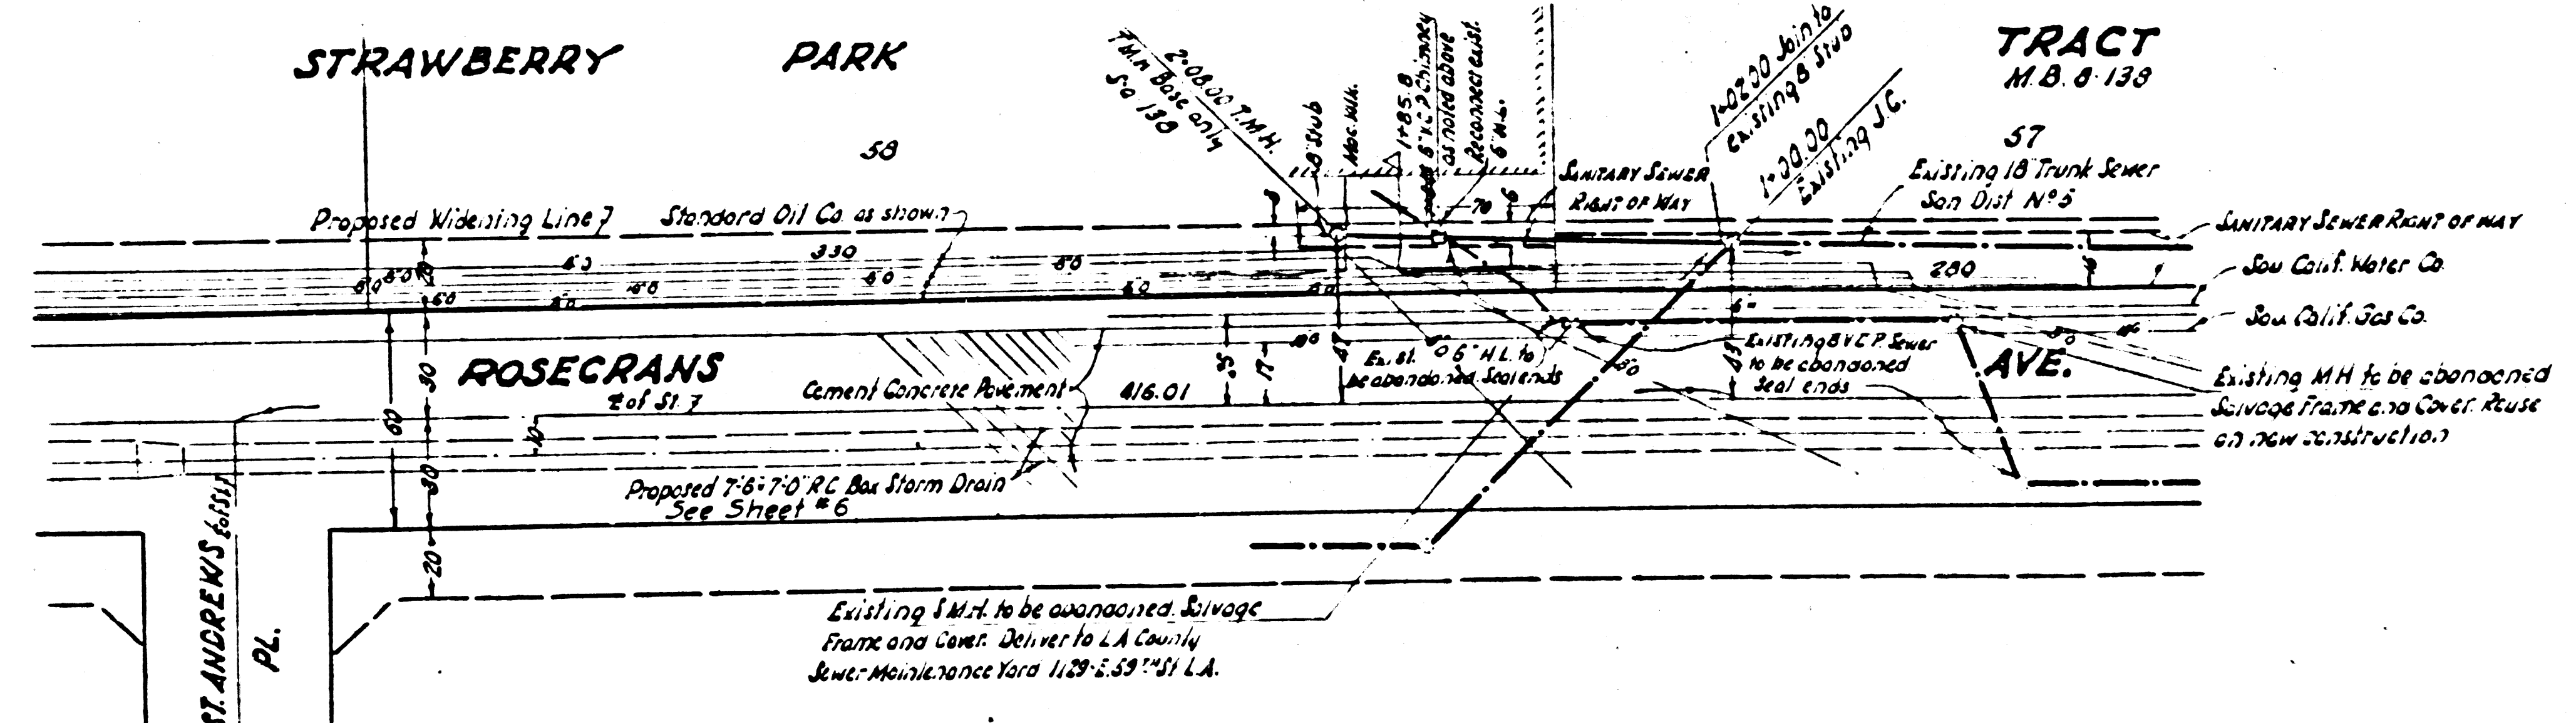


LYN MARKS STYLE V

LYN MARKS STYLE V

47392

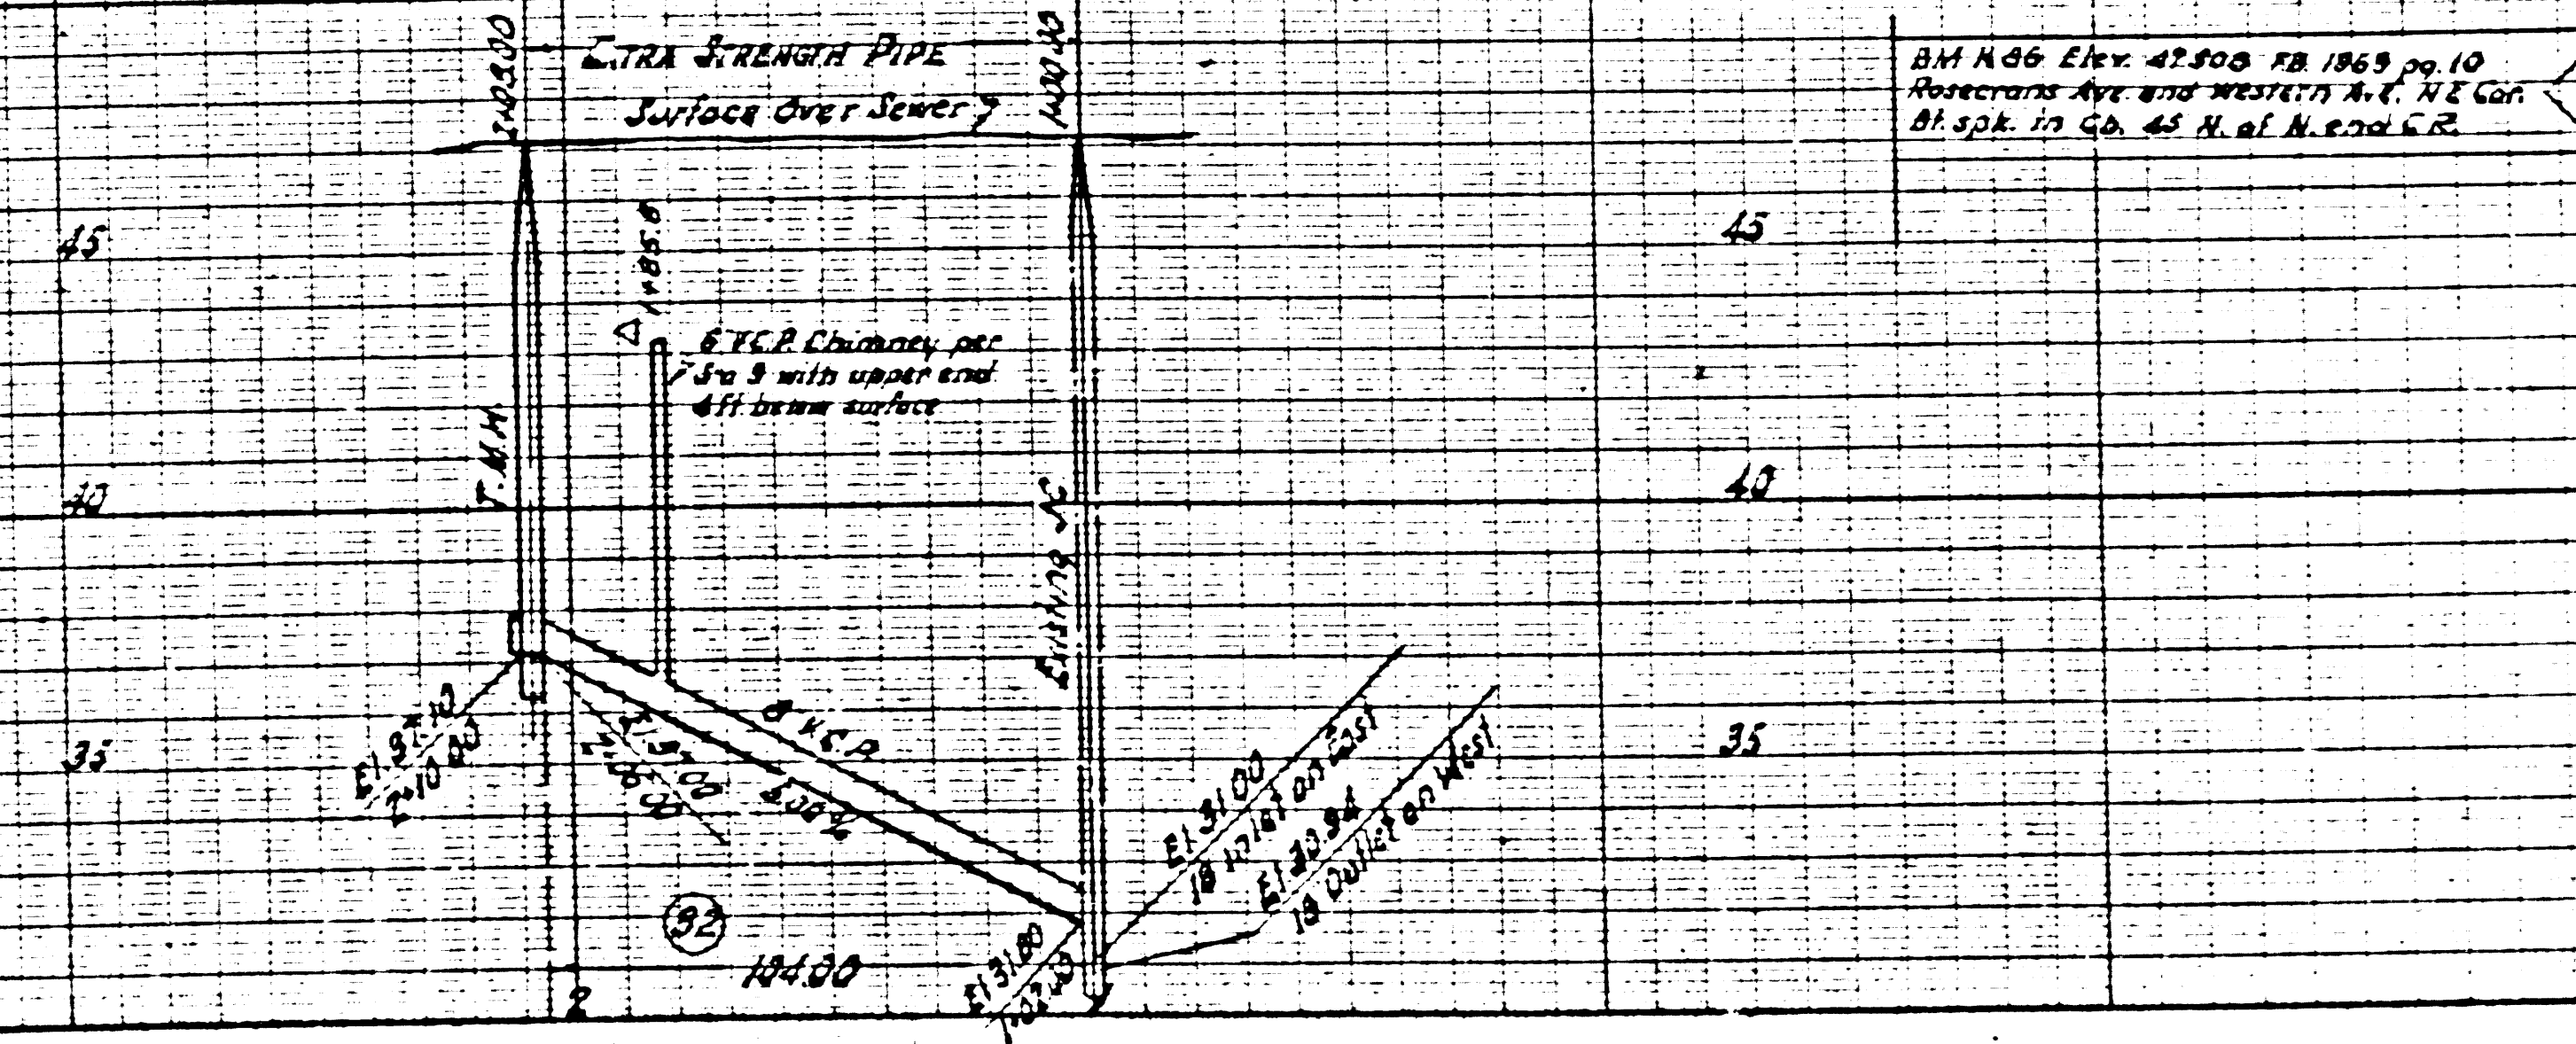

GENERAL SEWER NOTES
 1. For Location See Plan No. S-64
 2. Use Cement Mortar for all Vitrified Clay Pipe Joints.

H.N. 4122
 M-107
 NO POINT IN
 LENGTH DISTRICT OFFICE

REF. P.C. # 9789

PREPARED BY
WILLIAM J. FOX
COUNTY ENGINEER

RECOMMENDED BY
A.P. Collins
SUPERVISOR ENGINEER

DRAWN BY: *W.J.F.* CHECKED BY: *W.J.F.*
TRACED BY: *W.J.F.* SUBMITTED BY: *W.J.F.*
CHECKED BY: *W.J.F.* DATE: *SEPTEMBER, 1945*

REVISIONS	
MARK	DATE DESCRIPTION
Δ	5-10-57 As Built

COUNTY STORM DRAIN BOND ISSUE

LOS ANGELES COUNTY FLOOD CONTROL DISTRICT

PROJECT NO. 11
ROSECRANS AVE.
 SANITARY SEWER RECONSTRUCTION
 PLAN AND PROFILE

APPROVED BY: *W.J. Fox*
 COUNTY ENGINEER

SCALE: 1"=40'
 DATE: OCT 1955
 SHEET 13 OF 14