
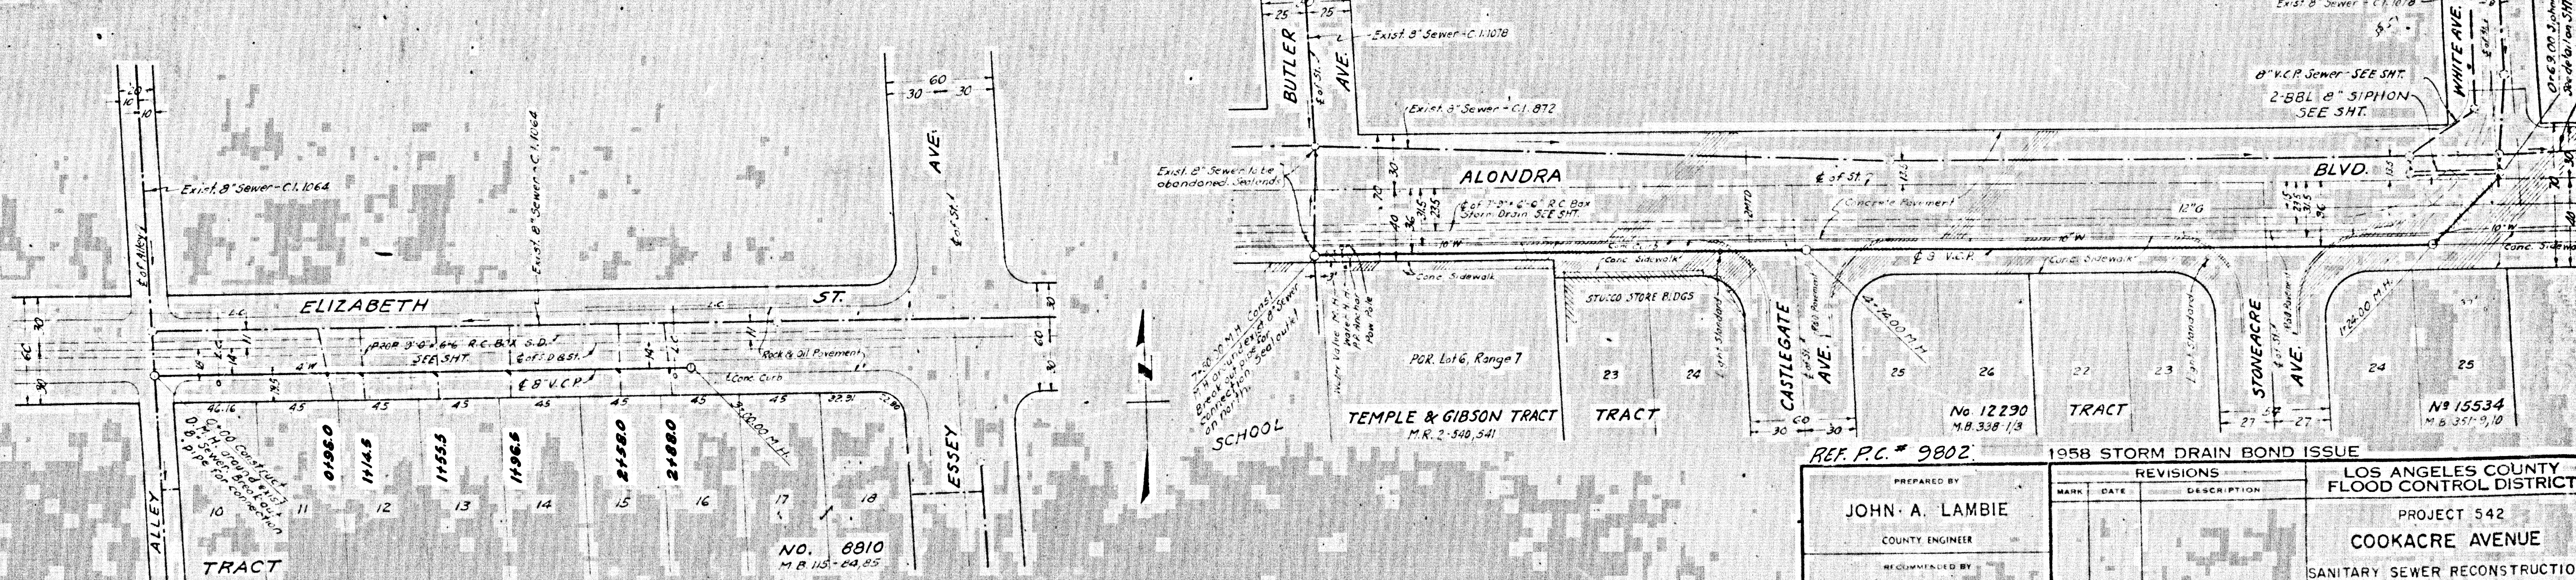


31904

PROFILE
HORIZ. SCALE: 1" = 40'
VERT. SCALE: 1" = 4'

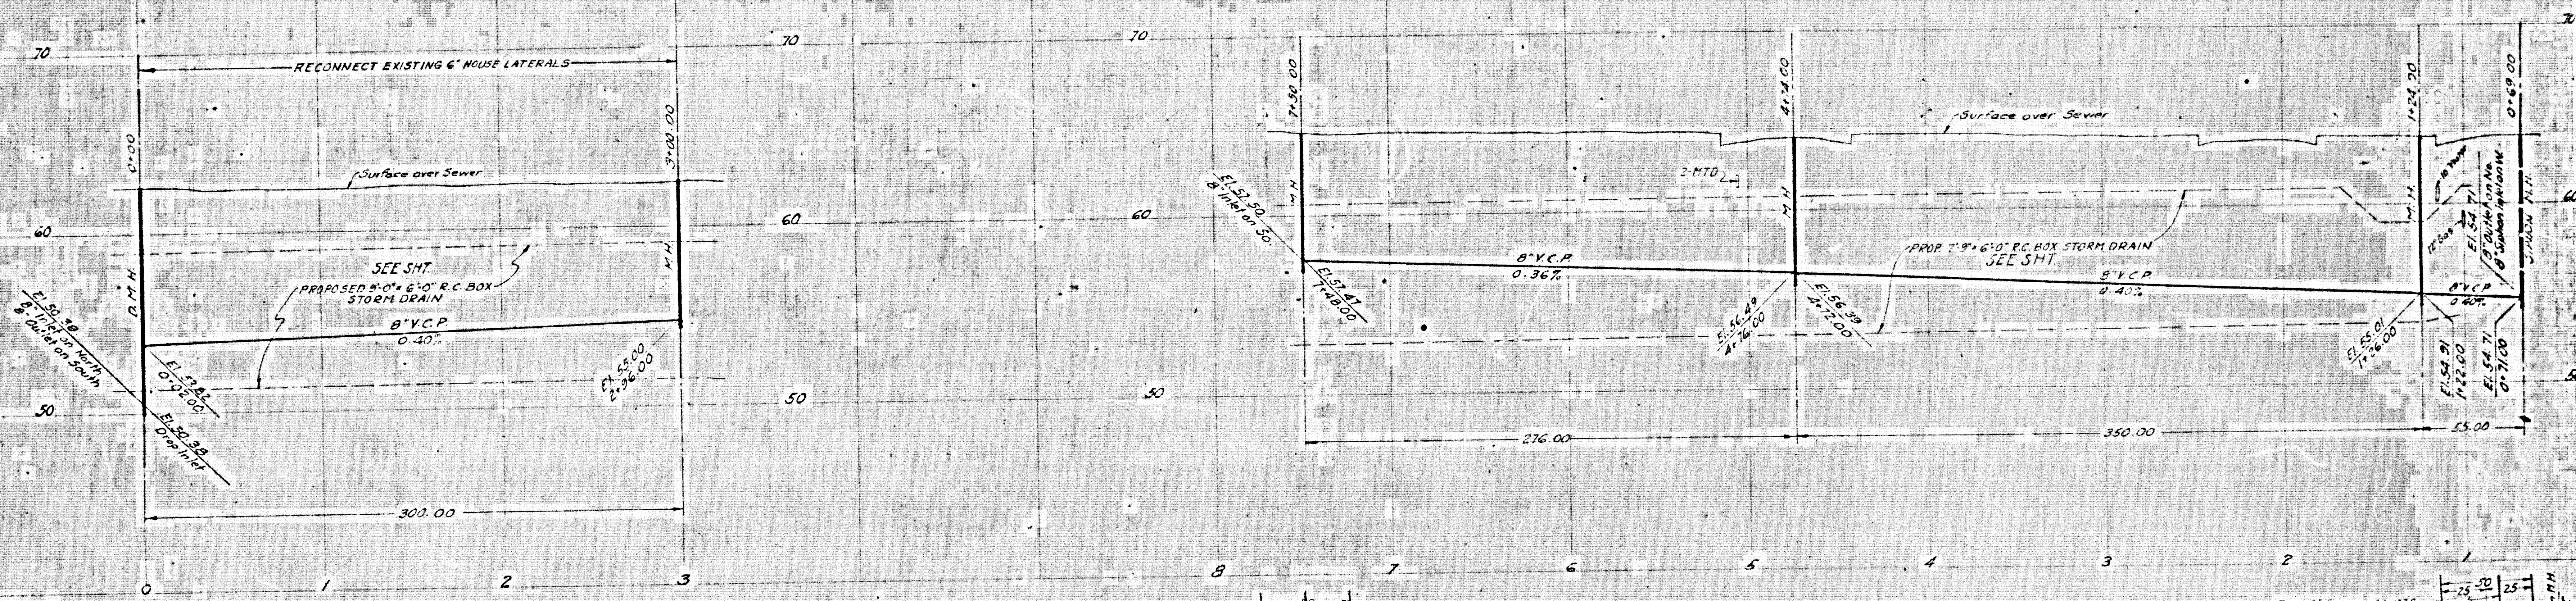

PLAN
SCALE: 1" = 40'

PREPARED BY JOHN A. LAMBIE COUNTY ENGINEER		REVISIONS MARK DATE DESCRIPTION		LOS ANGELES COUNTY FLOOD CONTROL DISTRICT	
RECOMMENDED BY <i>CE Family</i> COUNTY ENGINEER		APPROVED BY _____ COUNTY ENGINEER		PROJECT 542 COOKACRE AVENUE SANITARY SEWER RECONSTRUCTION PLAN AND PROFILE	
DRAWN BY _____	DESIGNED BY _____	CHECKED BY _____	REVISIONS _____	SCALE 1" = 40'	DATE MAY 1950

FILE COPY

REF. P.C. # 9802 (S.D. NO. 542)