
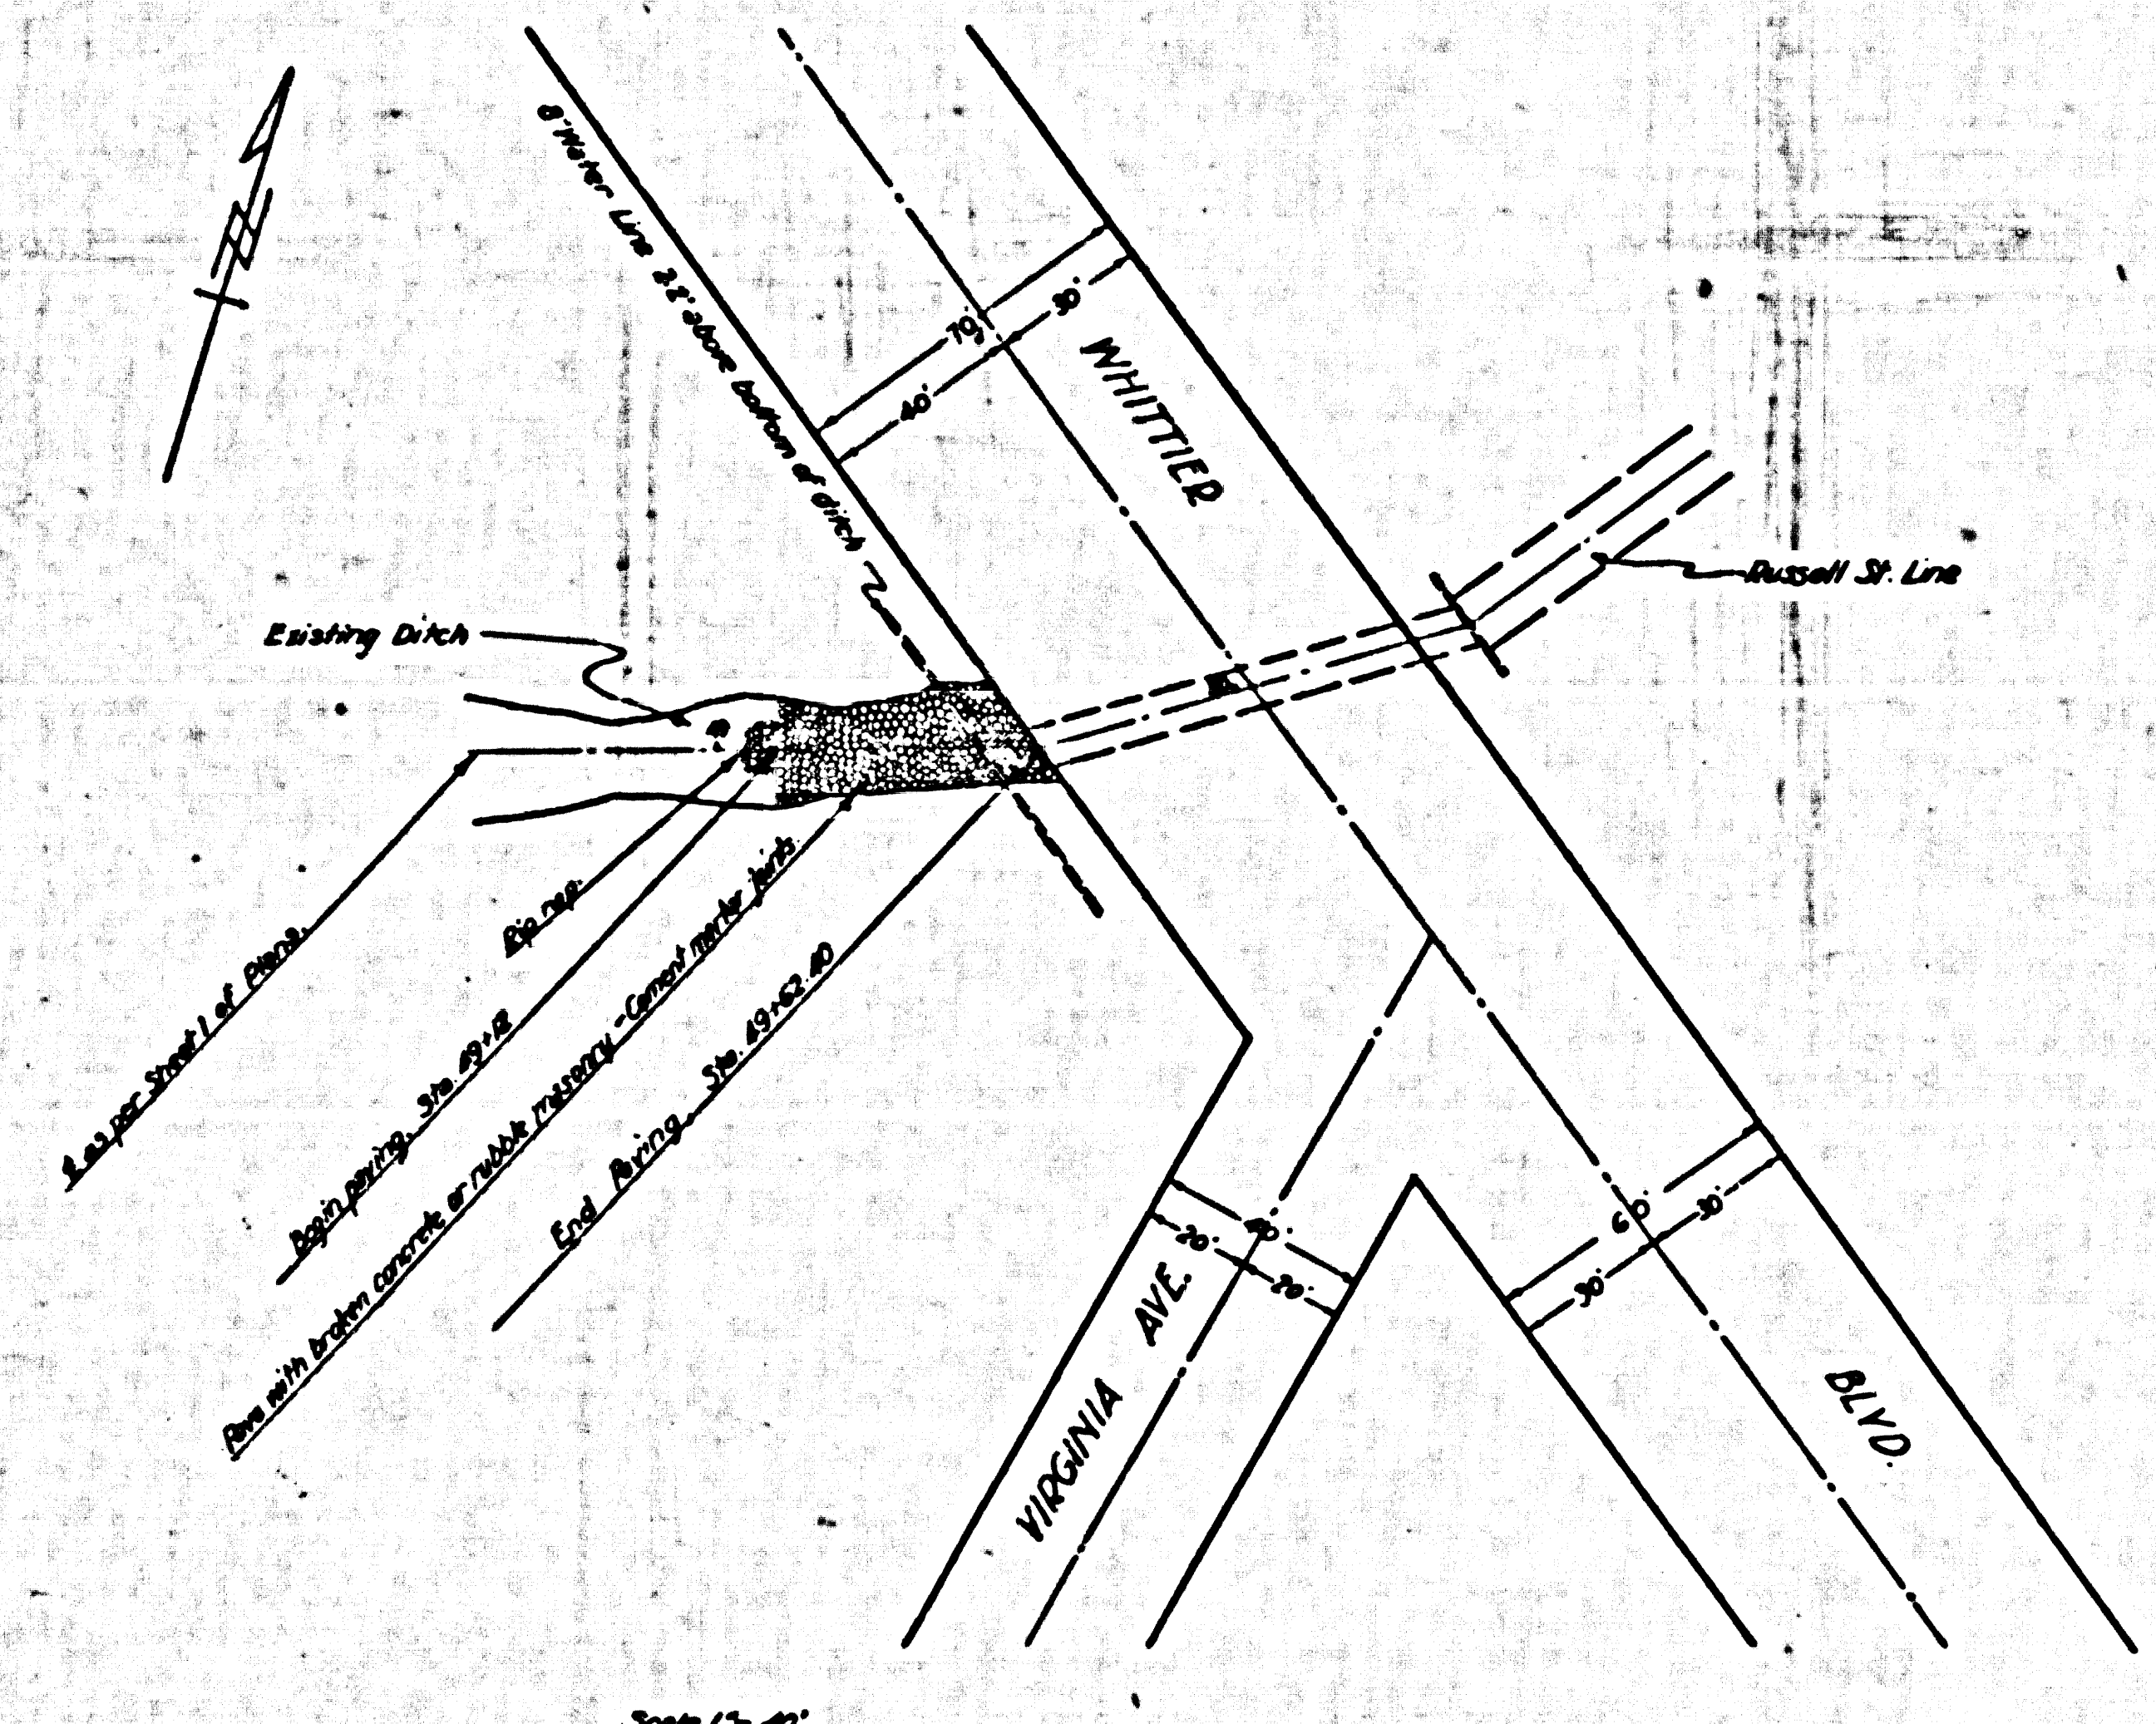


SHEET NO. 1-A OF 3 SHEETS
CONSULT SURVEYORS MAP NO. B-1180

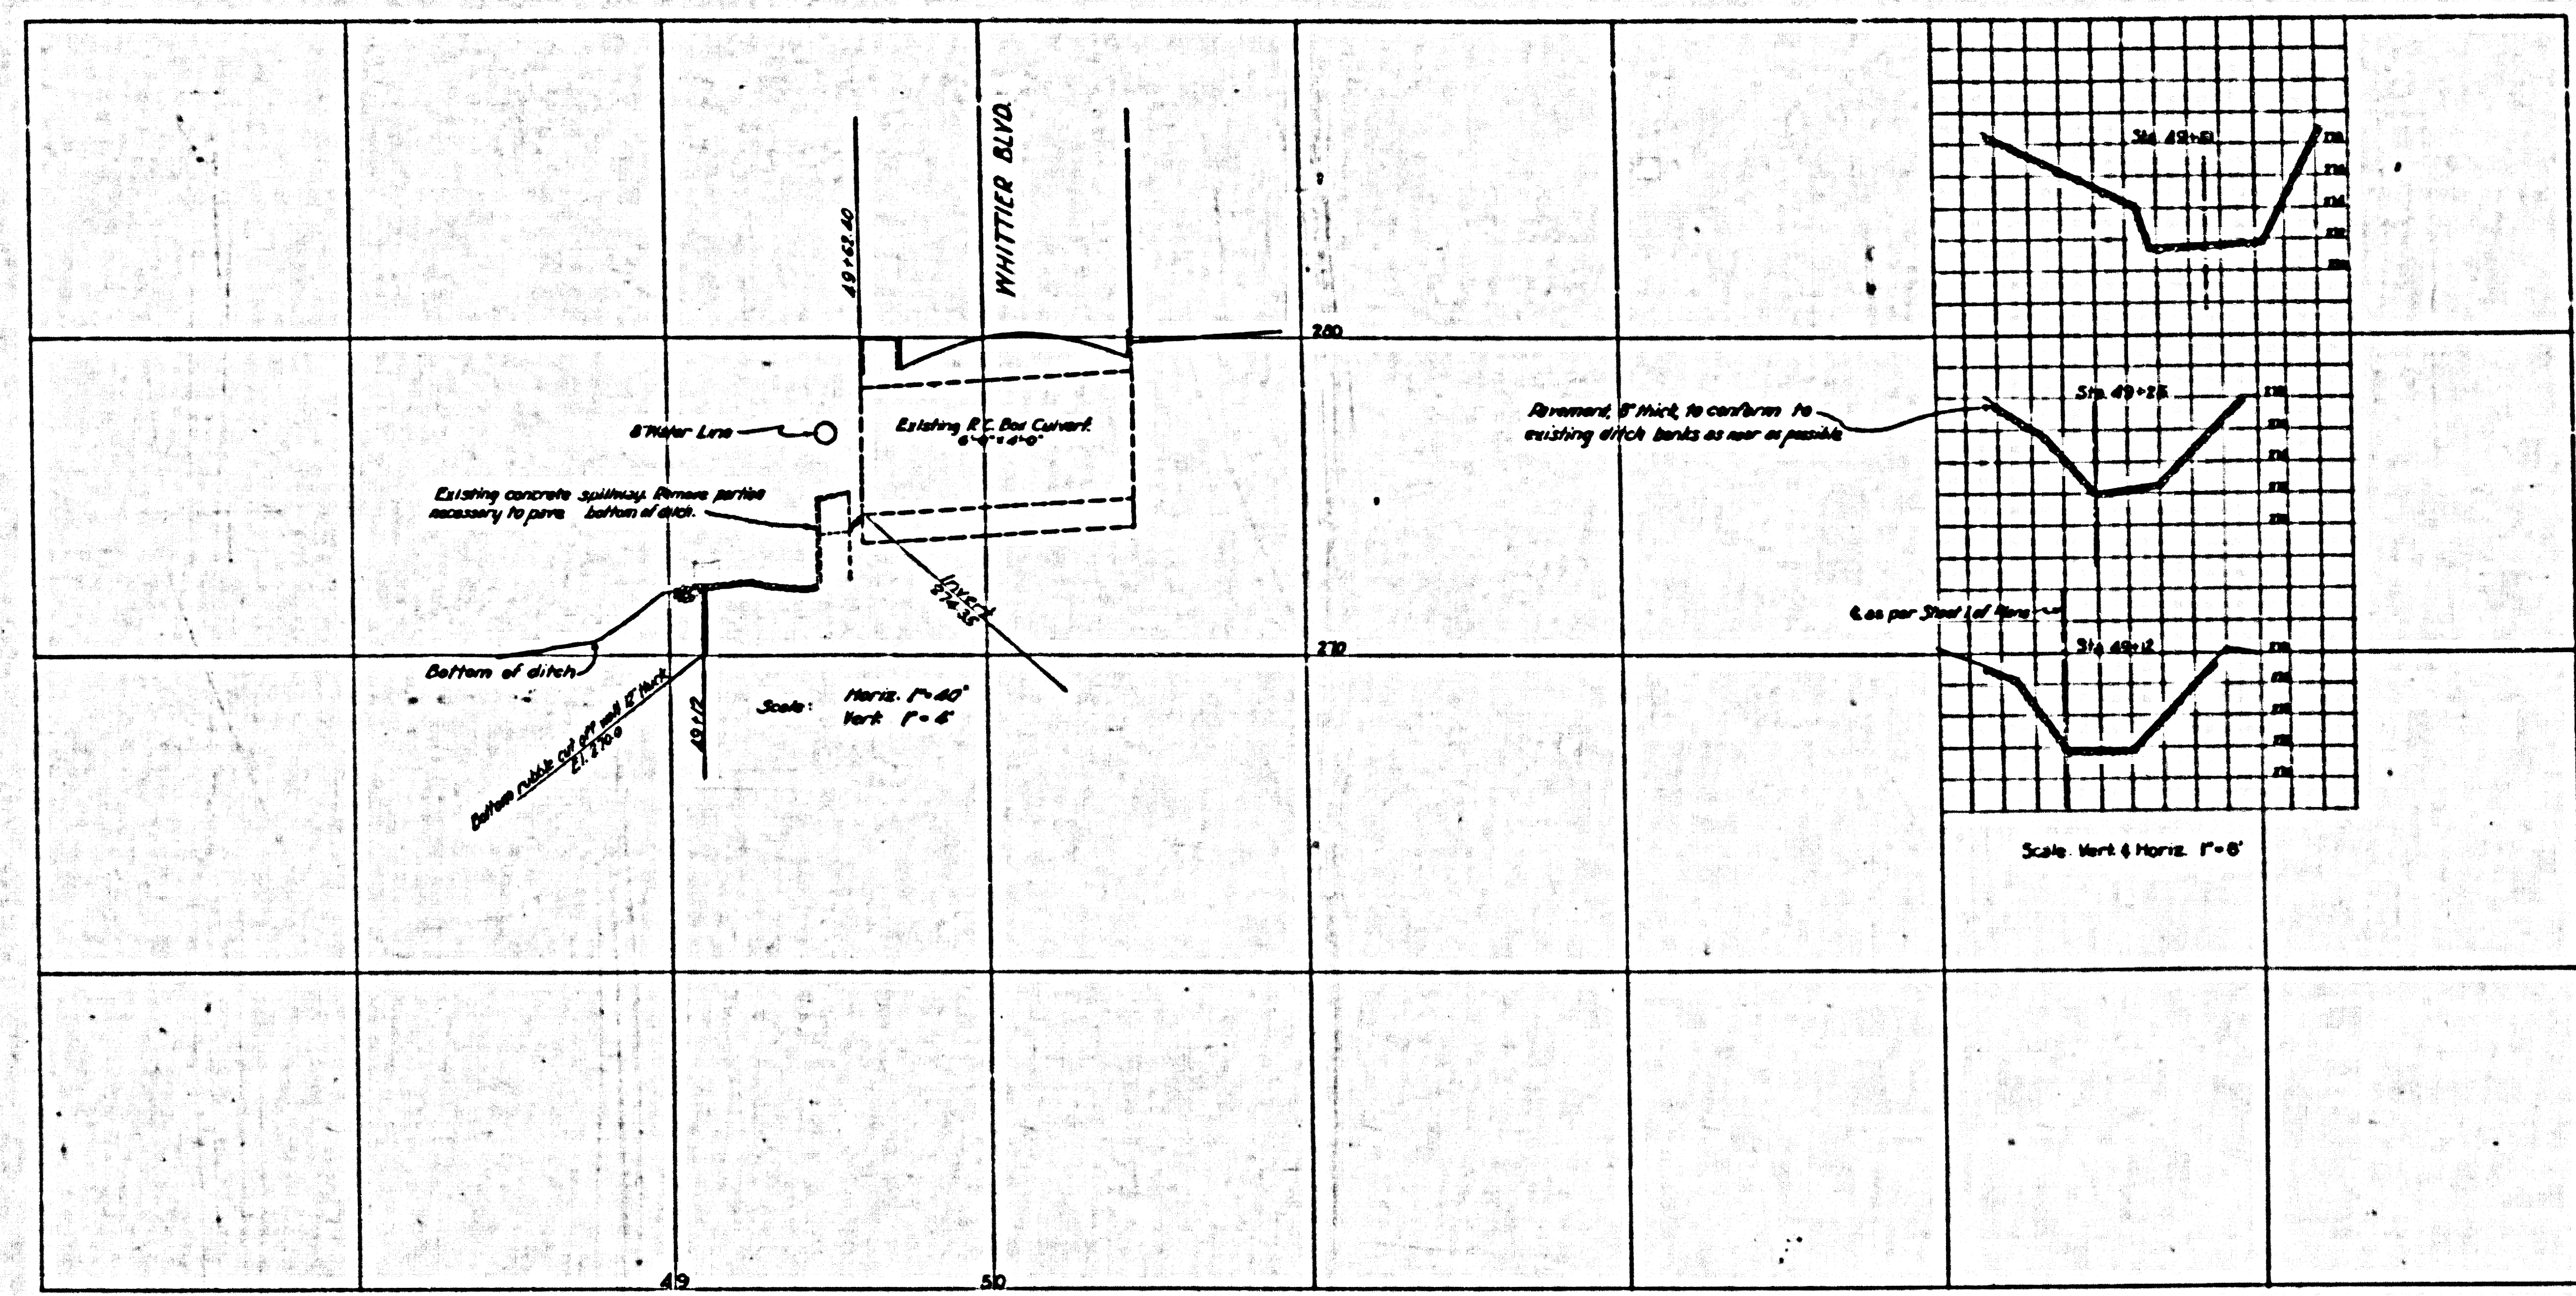

**RUSSELL STREET
DRAINAGE SYSTEM**
OF THE COUNTY OF LOS ANGELES, CALIFORNIA
PLAN AND PROFILE OF
RUSSELL ST. LINE
SUPPLEMENT TO SHEET 1 OF 3 SHEETS

Scale as noted. JANUARY 1930.
ALFRED JONES COUNTY ENGINEER.
RECOMMENDED *Edmund* CHIEF SURVEYOR. APPROVED *Alfred Jones*

REFERENCE		DRAWN	C.J. Rath	JAN 1930.
F.B.	539	TRACED	C.J. Rath	JAN 1930.
L.B.	755	CHECKED	J. L. Partin	JAN 1930.

CSB-1166-1-A
A10FA1

SHEET NO. 1-A OF 3 SHEETS
CONSULT SURVEYORS MAP NO. B-1180