


PROFILE  
 Horizontal - 1" = 60'  
 Vertical - 1" = 5'

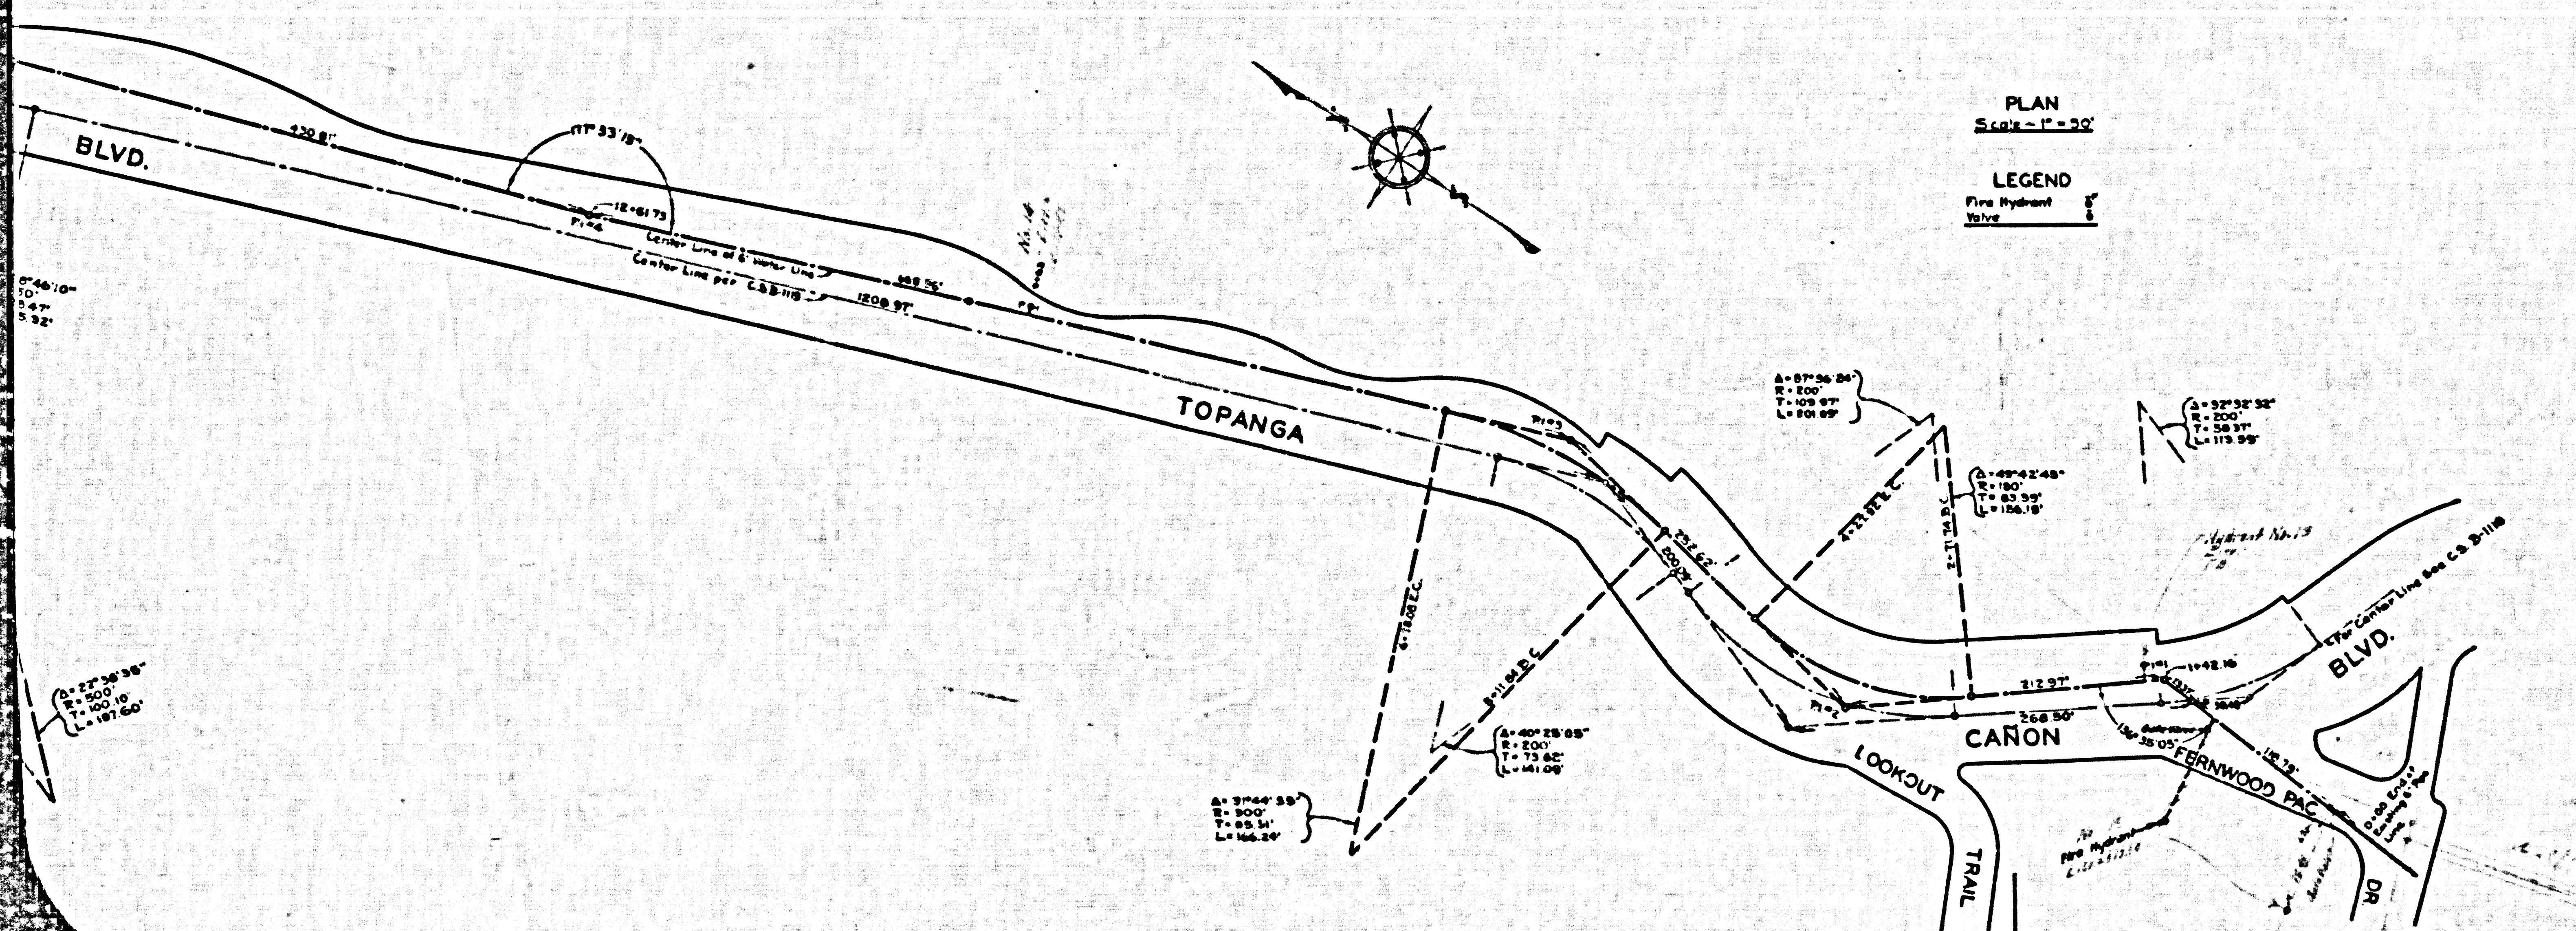

PLAN  
 Scale - 1" = 30'

LEGEND  
 Fire Hydrant  
 Valve

PLAN AND PROFILE OF  
 FIRE CISTERN SYSTEM PIPE LINE

FROM  
 FERNWOOD AND PACIFIC DRIVE  
 TO  
 CHENEY DRIVE

COUNTY SURVEYOR'S MAP NO B-1626  
 SHEET NO. 1 OF 3 SHEETS  
 SCALES AS SHOWN

JOB NUMBER 8211  
 ALFRED JONES - COUNTY SURVEYOR  
 SURVEYED JUNE - NOVEMBER 1940

SURVEYED UPON: REQUEST OF THE MECHANICAL  
 DEPARTMENT PER RULE 31, ORDINANCE 929, BY  
 LETTER DATED JUNE 12, 1940



F. B. 695 - 100-208

FIELD WORK BY L. S. HAMMOND  
 OFFICE WORK BY L. R. FREEMAN  
 CHECKED BY J. A. LYON


DATUM - MEAN SEA LEVEL  
 ELEVATIONS SHOWN HEREON ARE BASED ON  
 1929 U.S.C.G.S. ADJUSTMENT OF U.S.G.S. B.M.  
 73.204 - 1927 (U.S. 1940)

NOTE: SHEETS 2 & 3 WERE ADDED TO  
 THIS MAP OCTOBER 1947

CSB-1626-1  
 A1 OF A3

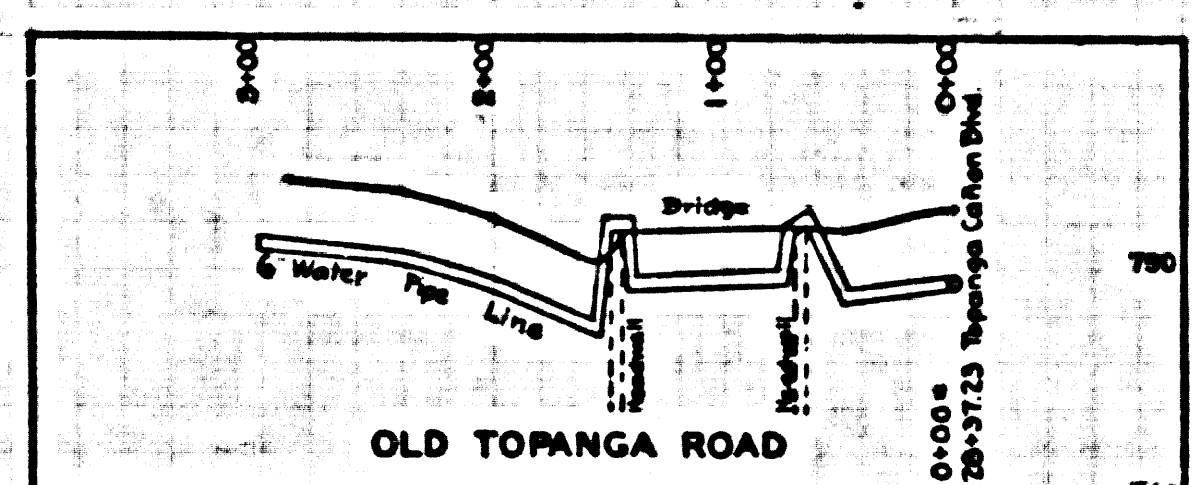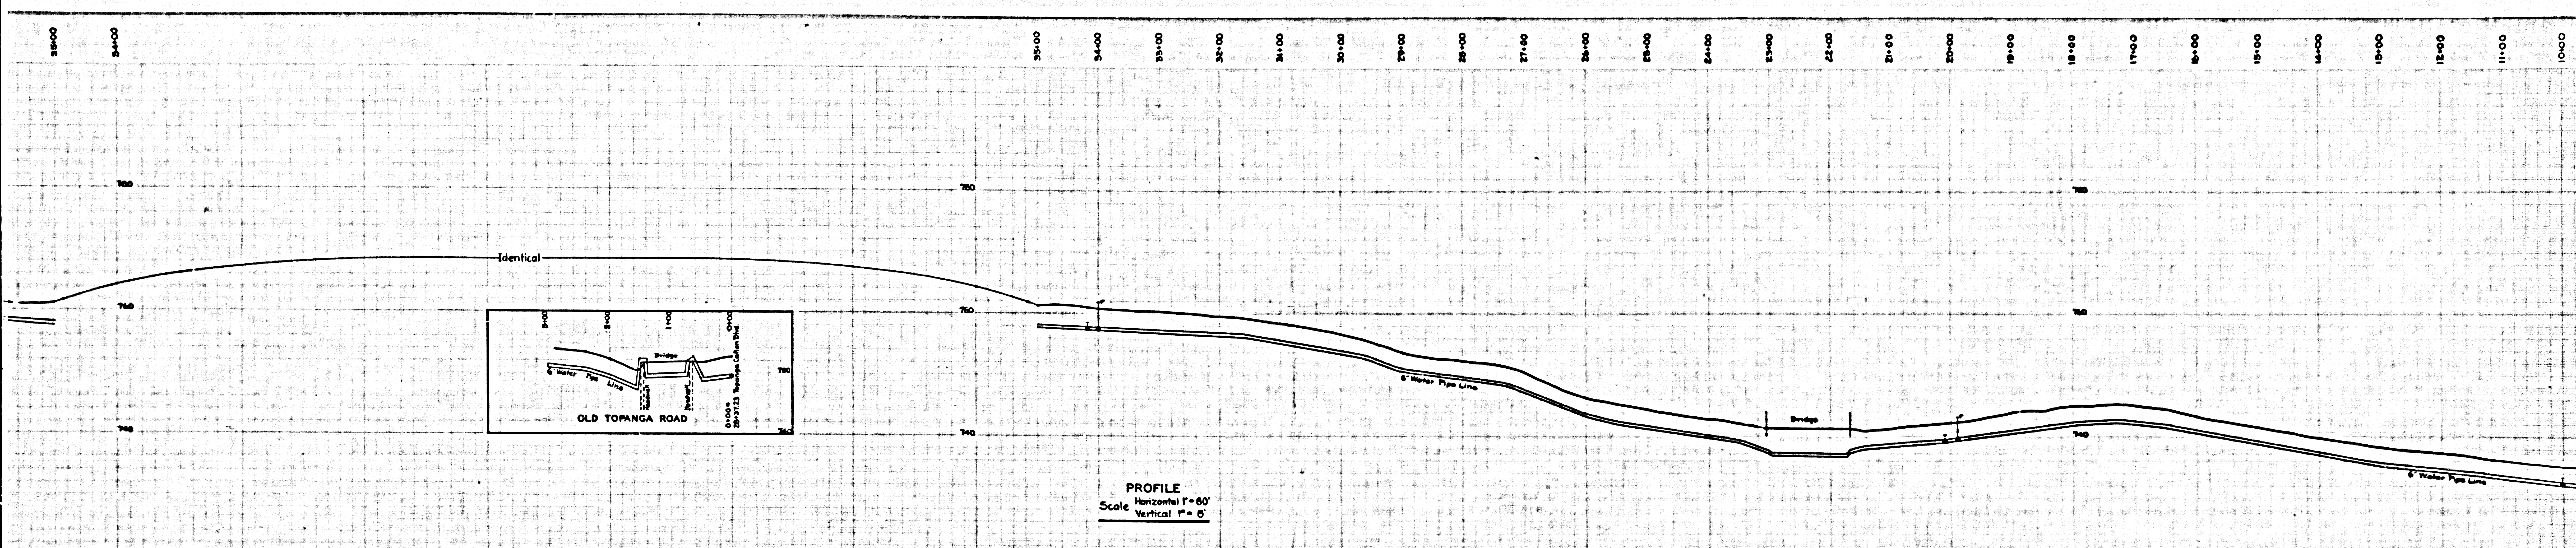


PROFILE  
 Horizontal 1" = 50'  
 Vertical 1" = 5'

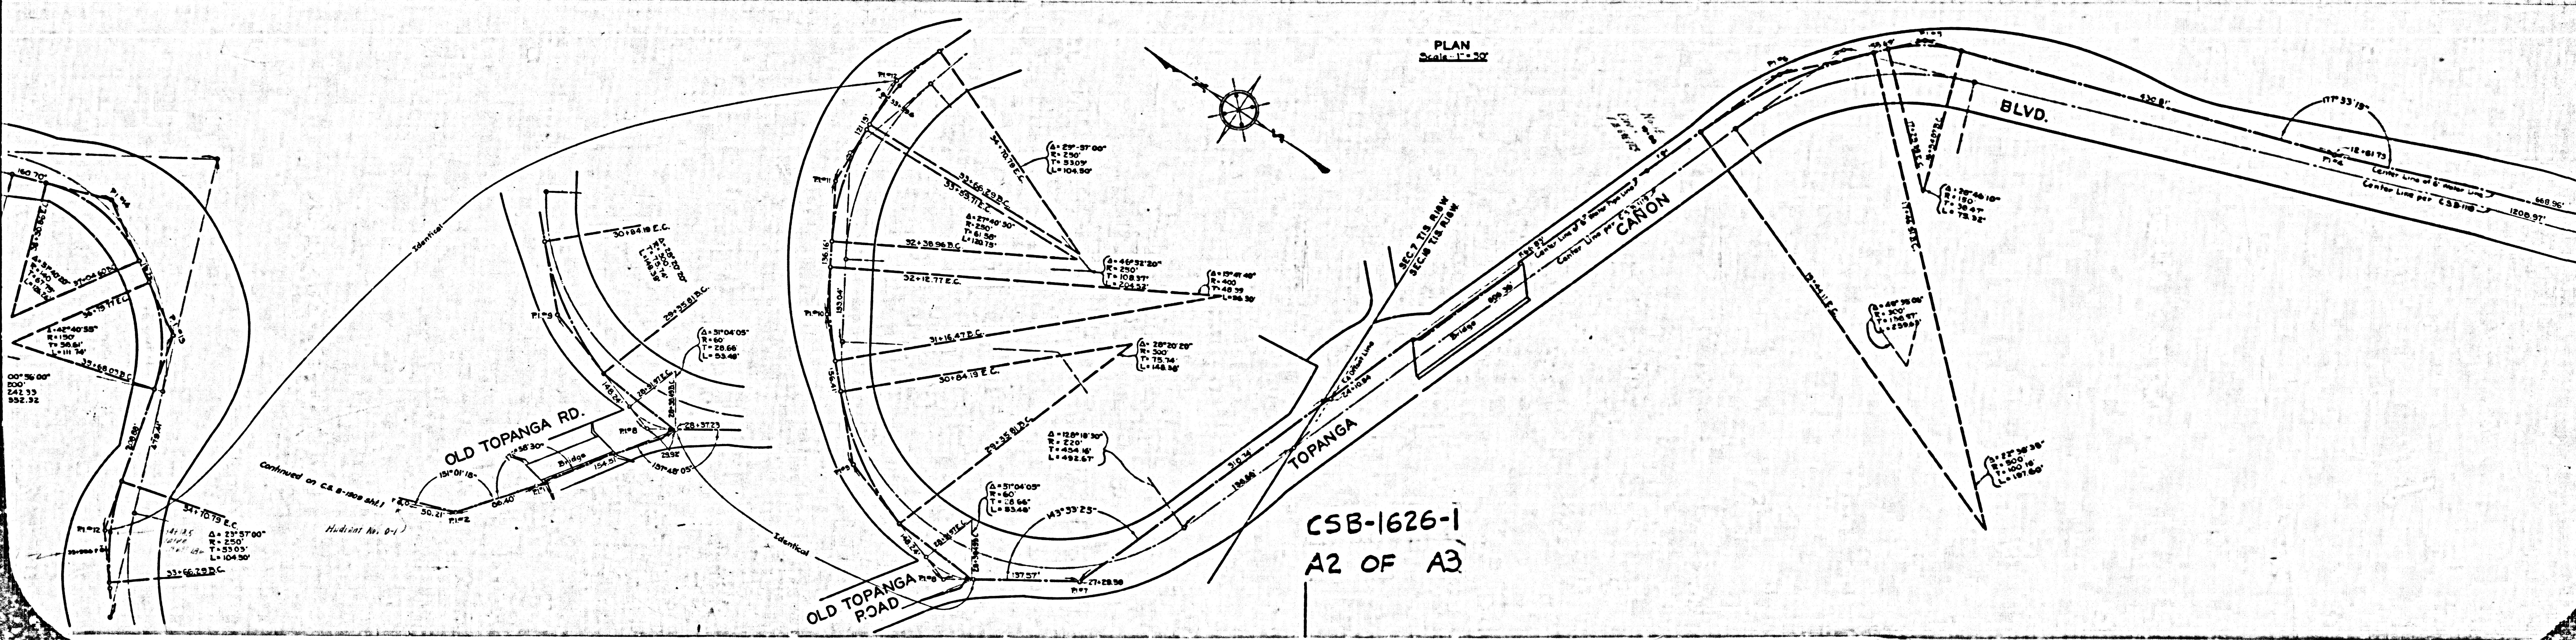

PLAN  
 Scale 1" = 20'


CSB-1626-1  
 A2 OF A3

41+00 42+00 43+00 44+00 45+00 46+00 47+00 48+00 49+00 50+00 51+00 52+00 53+00 54+00

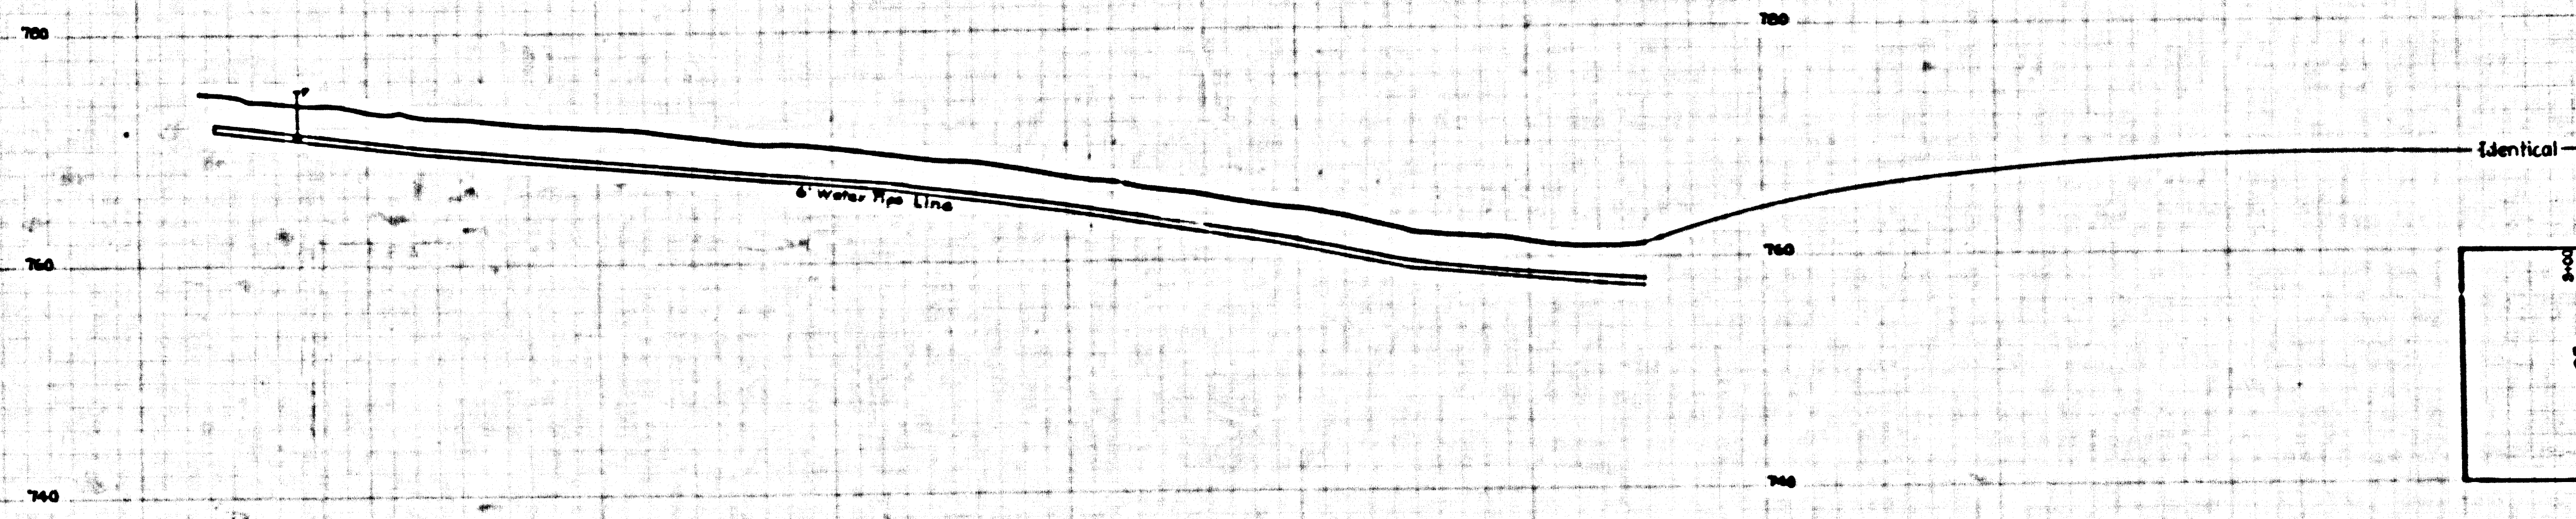

PROFILE  
Scale Horizontal 1"=60'  
Vertical 1"=8'

PLAN  
Scale 1"=20'

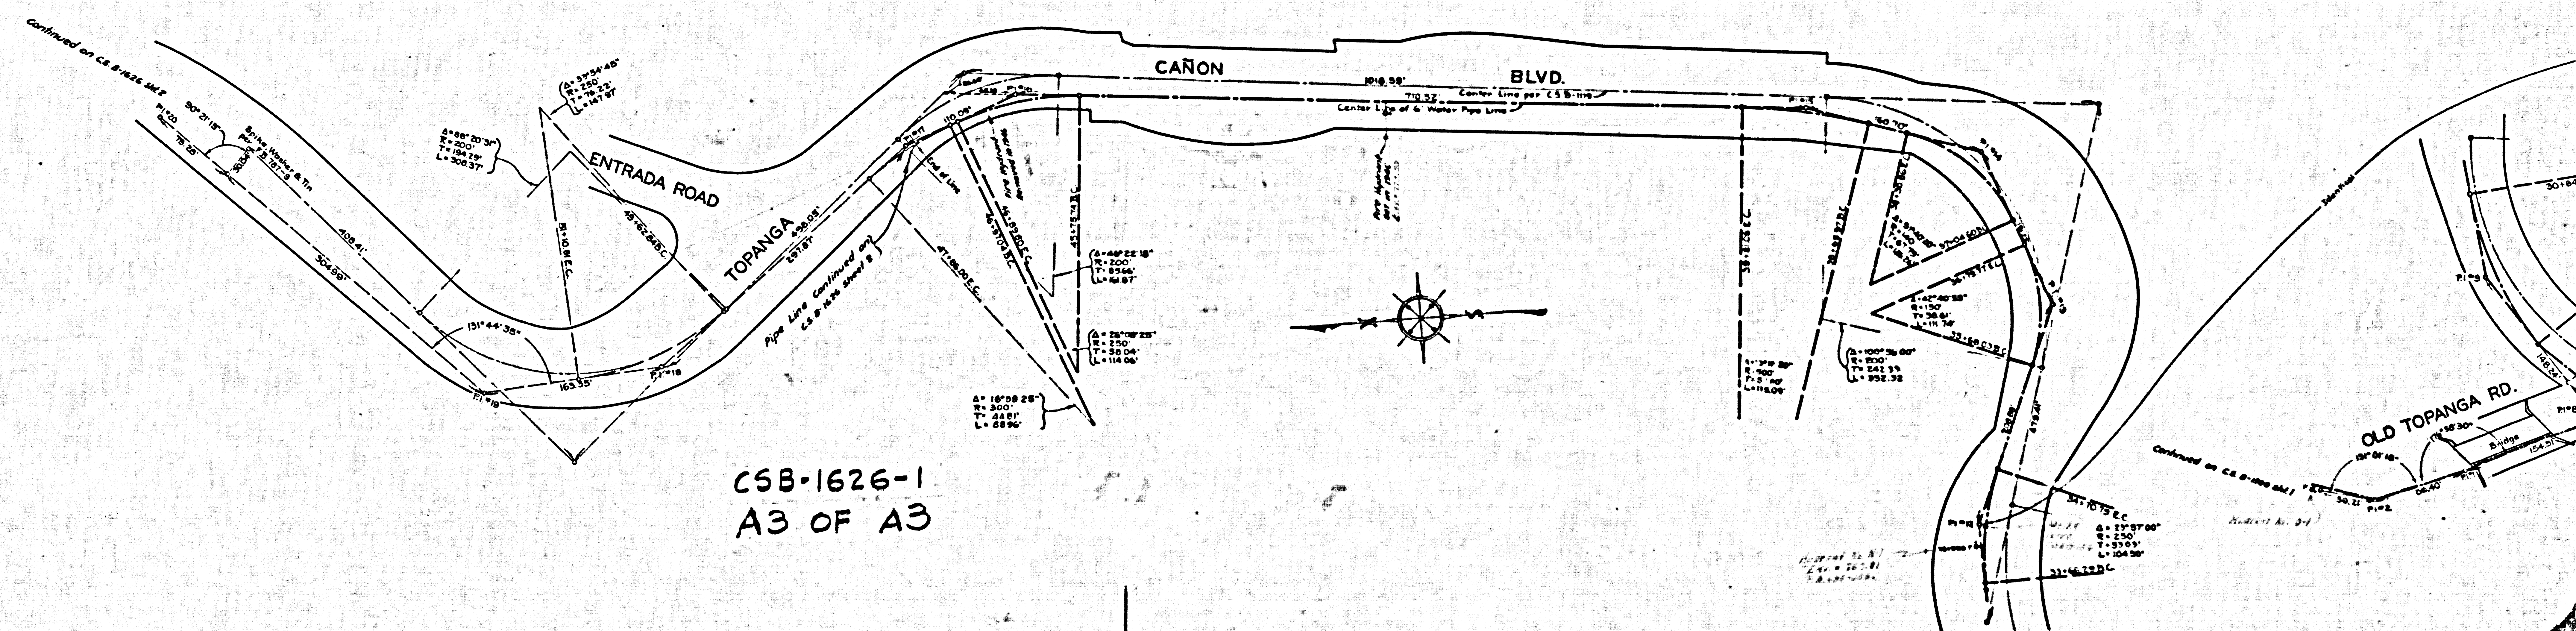

CSB-1626-1  
A3 OF A3

